


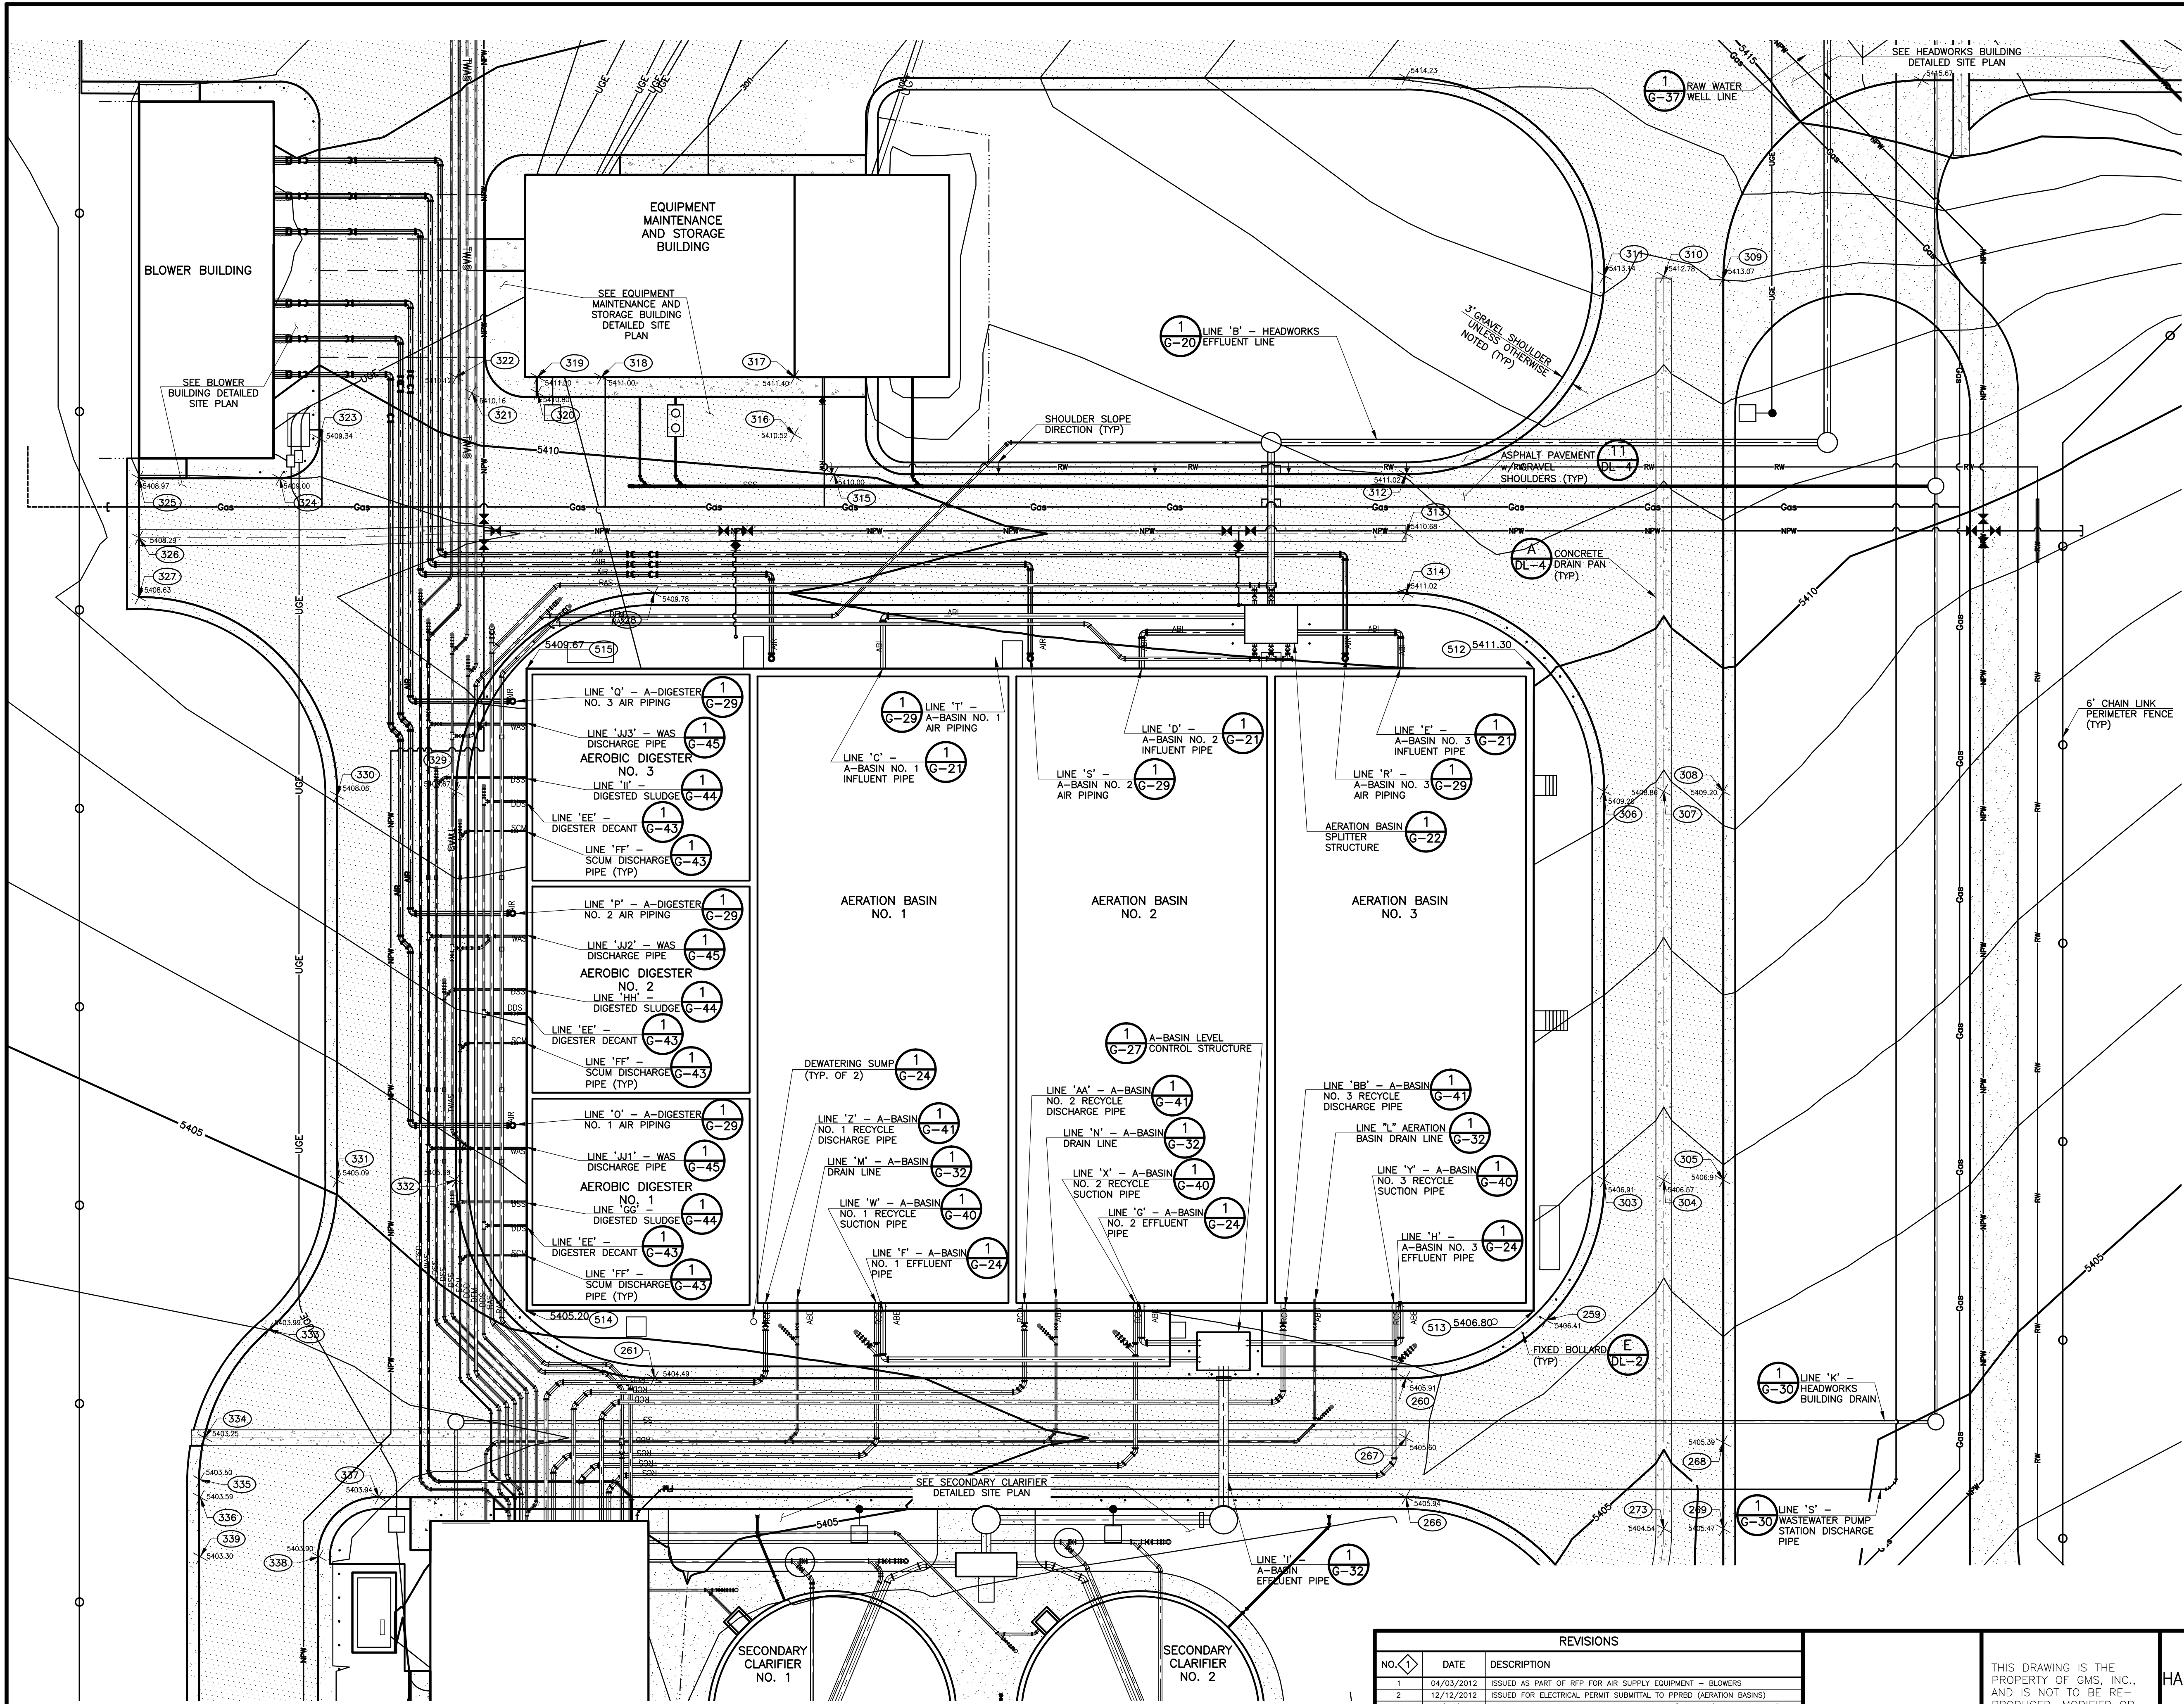

1 AERATION BASIN DETAILED SITE PLAN
 AB-10 SCALE: 1" = 20'

REVISIONS		
NO.	DATE	DESCRIPTION
1	04/03/2012	ISSUED AS PART OF RFP FOR AIR SUPPLY EQUIPMENT - BLOWERS
2	12/12/2012	ISSUED FOR ELECTRICAL PERMIT SUBMITTAL TO PPRBD (AERATION BASINS)
3	01/29/2013	ISSUED FOR CONSTRUCTION PER PPRBD PERMIT #H64746 (AERATION BASINS)

THIS DRAWING IS THE PROPERTY OF GMS, INC., AND IS NOT TO BE REPRODUCED, MODIFIED OR USED FOR ANY OTHER PROJECT OR EXTENSION OF THIS PROJECT EXCEPT BY AGREEMENT WITH THIS COMPANY.

DETAILED SITE PLAN HAROLD D. THOMPSON REGIONAL WATER RECLAMATION FACILITY LOWER FOUNTAIN METROPOLITAN SEWAGE DISPOSAL DISTRICT		GMS, INC. CONSULTING ENGINEERS 611 N. WEBER, SUITE 300 COLORADO SPRINGS, COLORADO 80903	SHEET AB-10 OF —
DRAWN: SKC DESIGNED: MAM CHECKED: RJS DATE: 2011 PROJECT NO.: 20166.362 GMS FILE NO.: 2599			

G:\UNSWD\2010\08\25\AB10.dwg, 24.06, 1/20/2013 3:38:31 AM, 4: DWG TO PDF PLOT, 1:1

XREF FILENAME: G:\
 BASE DWG: G:\
 PLOT STYLE FILE: 1000.ctb
 FILENAME: G:\UNSWD\2010\08\25\AB10.dwg