


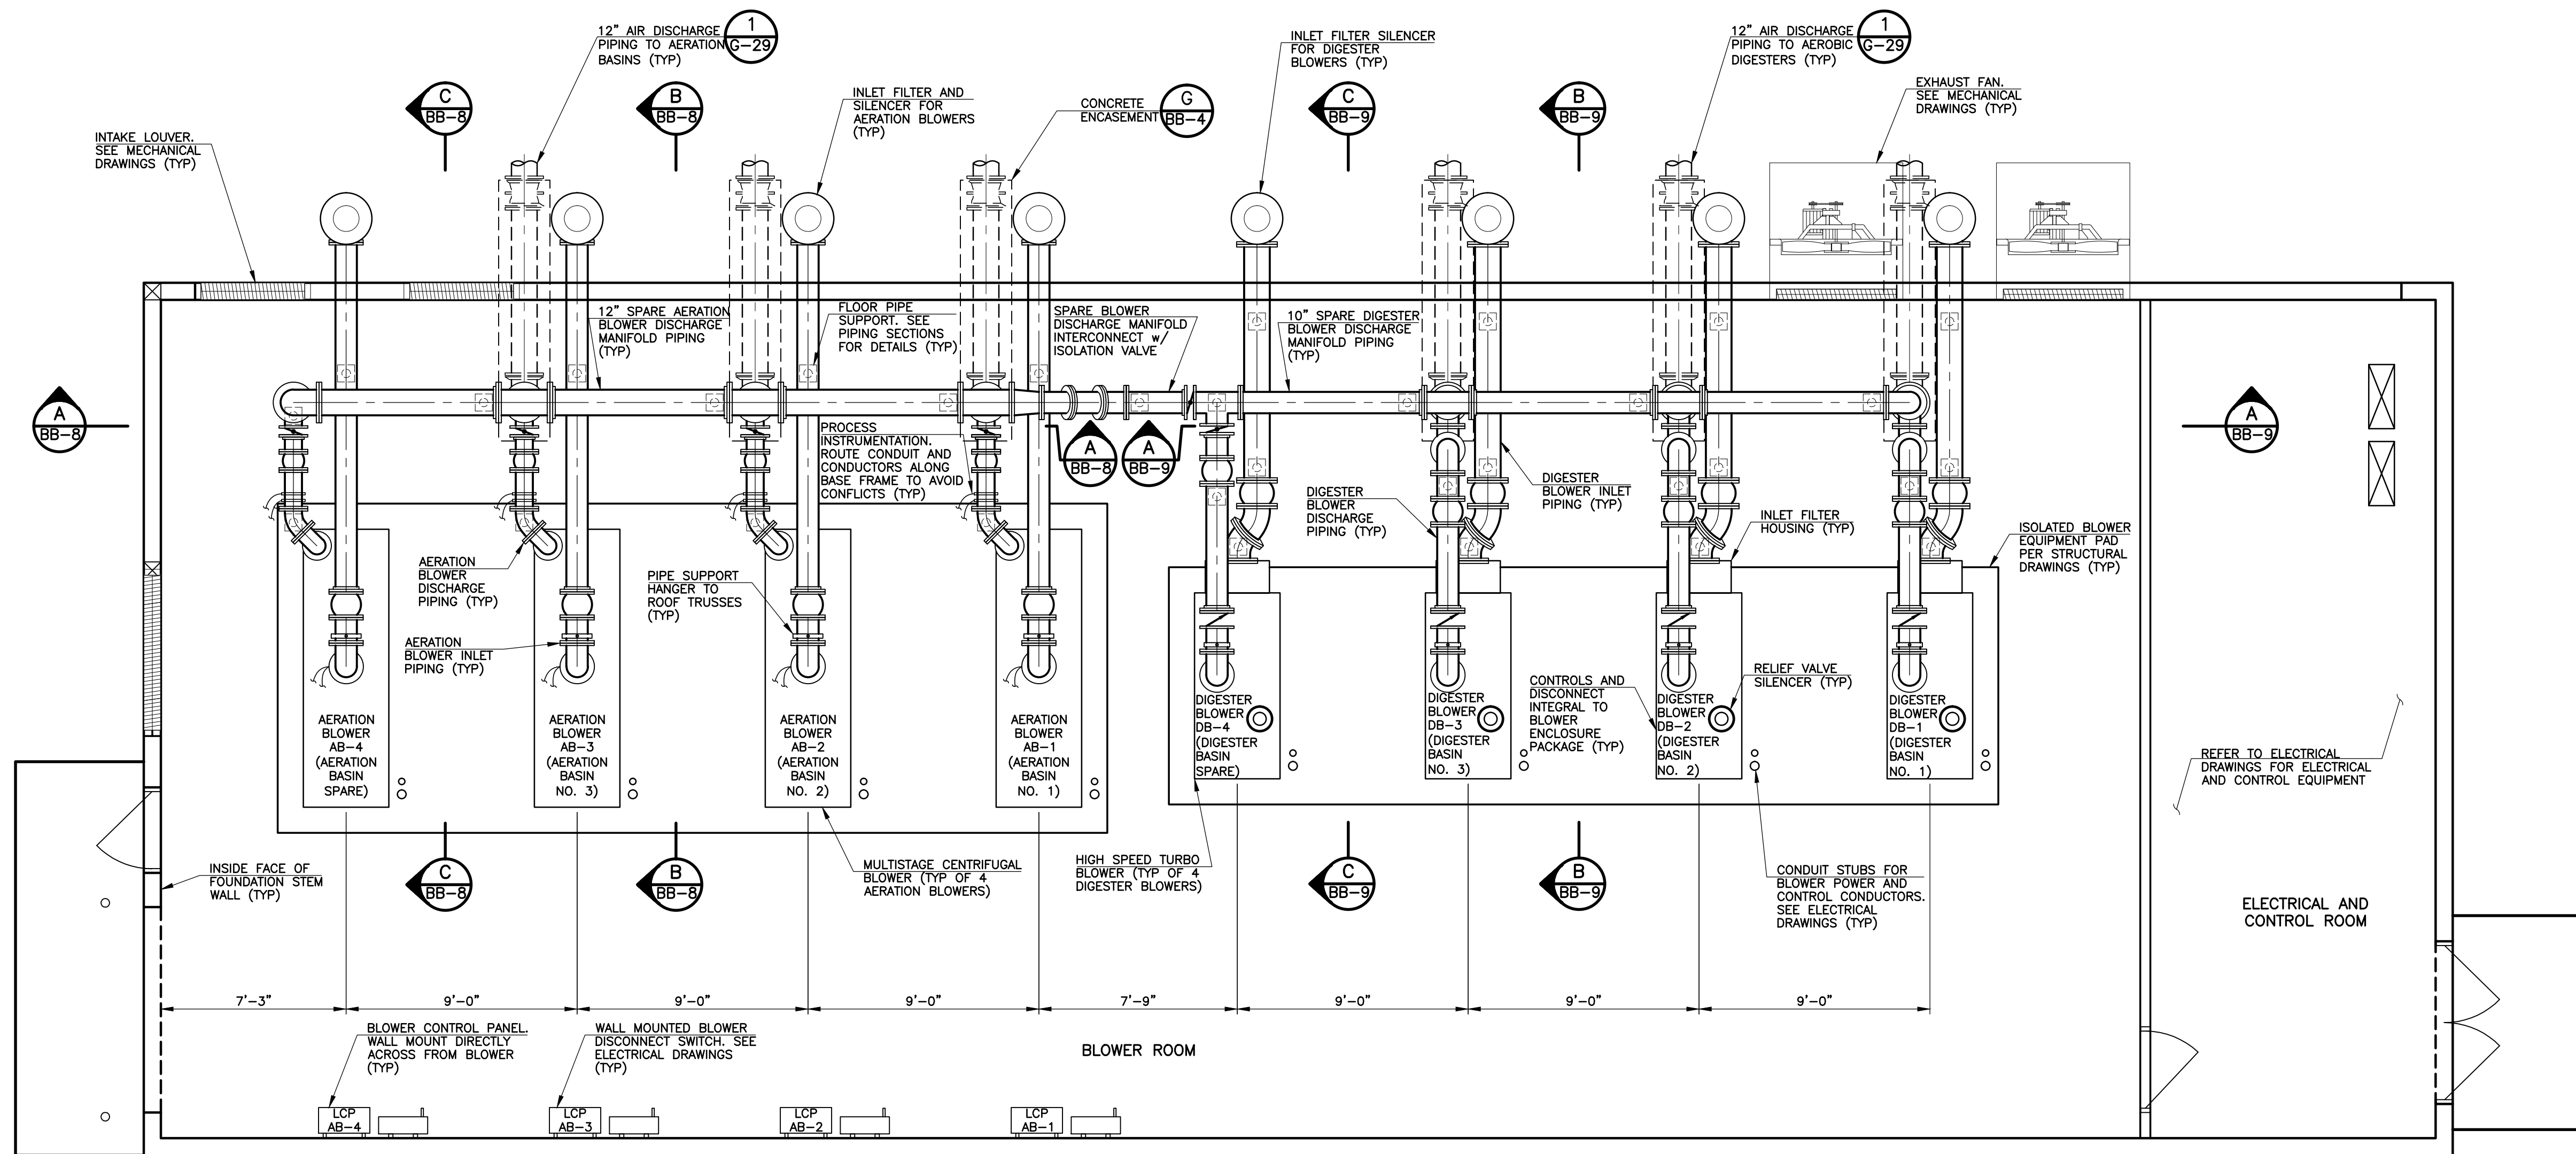

1 BLOWER BUILDING PROCESS EQUIPMENT AND PIPING PLAN
BB-7 SCALE: 1/4" = 1'-0"

REVISIONS		
NO.	DATE	DESCRIPTION
1	11/02/2010	PRELIMINARY ISSUE FOR PIPE COST QUOTATIONS
2	06/14/2012	ISSUED FOR VALUE ENGINEERING REVIEW AND COMMENT
3	06/21/2012	ISSUED FOR BUILDING PERMIT SUBMITTAL TO PPRBD (BLOWER BUILDING)
4	07/17/2012	ISSUED FOR CONSTRUCTION PER PPRBD BLDG PERMIT NO. 129081 (BLOWER BLDG)

THIS DRAWING IS THE
PROPERTY OF GMS, INC.,
AND IS NOT TO BE RE-
PRODUCED, MODIFIED OR
USED FOR ANY OTHER
PROJECT OR EXTENSION
OF THIS PROJECT EXCEPT
BY AGREEMENT WITH THIS
COMPANY.

© 2010 GMS, INC.

PROCESS EQUIPMENT AND PIPING PLAN
HAROLD D. THOMPSON REGIONAL WATER RECLAMATION FACILITY
LOWER FOUNTAIN METROPOLITAN SEWAGE DISPOSAL DISTRICT

DRAWN MAM
DESIGNED MAM
CHECKED RJS
DATE APRIL 2009
PROJECT NO. 20166.362
GMS FILE NO. 2599

GMS, INC.
CONSULTING ENGINEERS
611 N. WEBER, SUITE 300
COLORADO SPRINGS, COLORADO 80903

SHEET
BB-7
OF
—

XREF FILENAME: G:\
BASE DWG: G:\
PLOT STYLE FILE: 1055C.DWG
FILENAME: G:\FM5DD\20166\362\BB7\BB7.DWG