



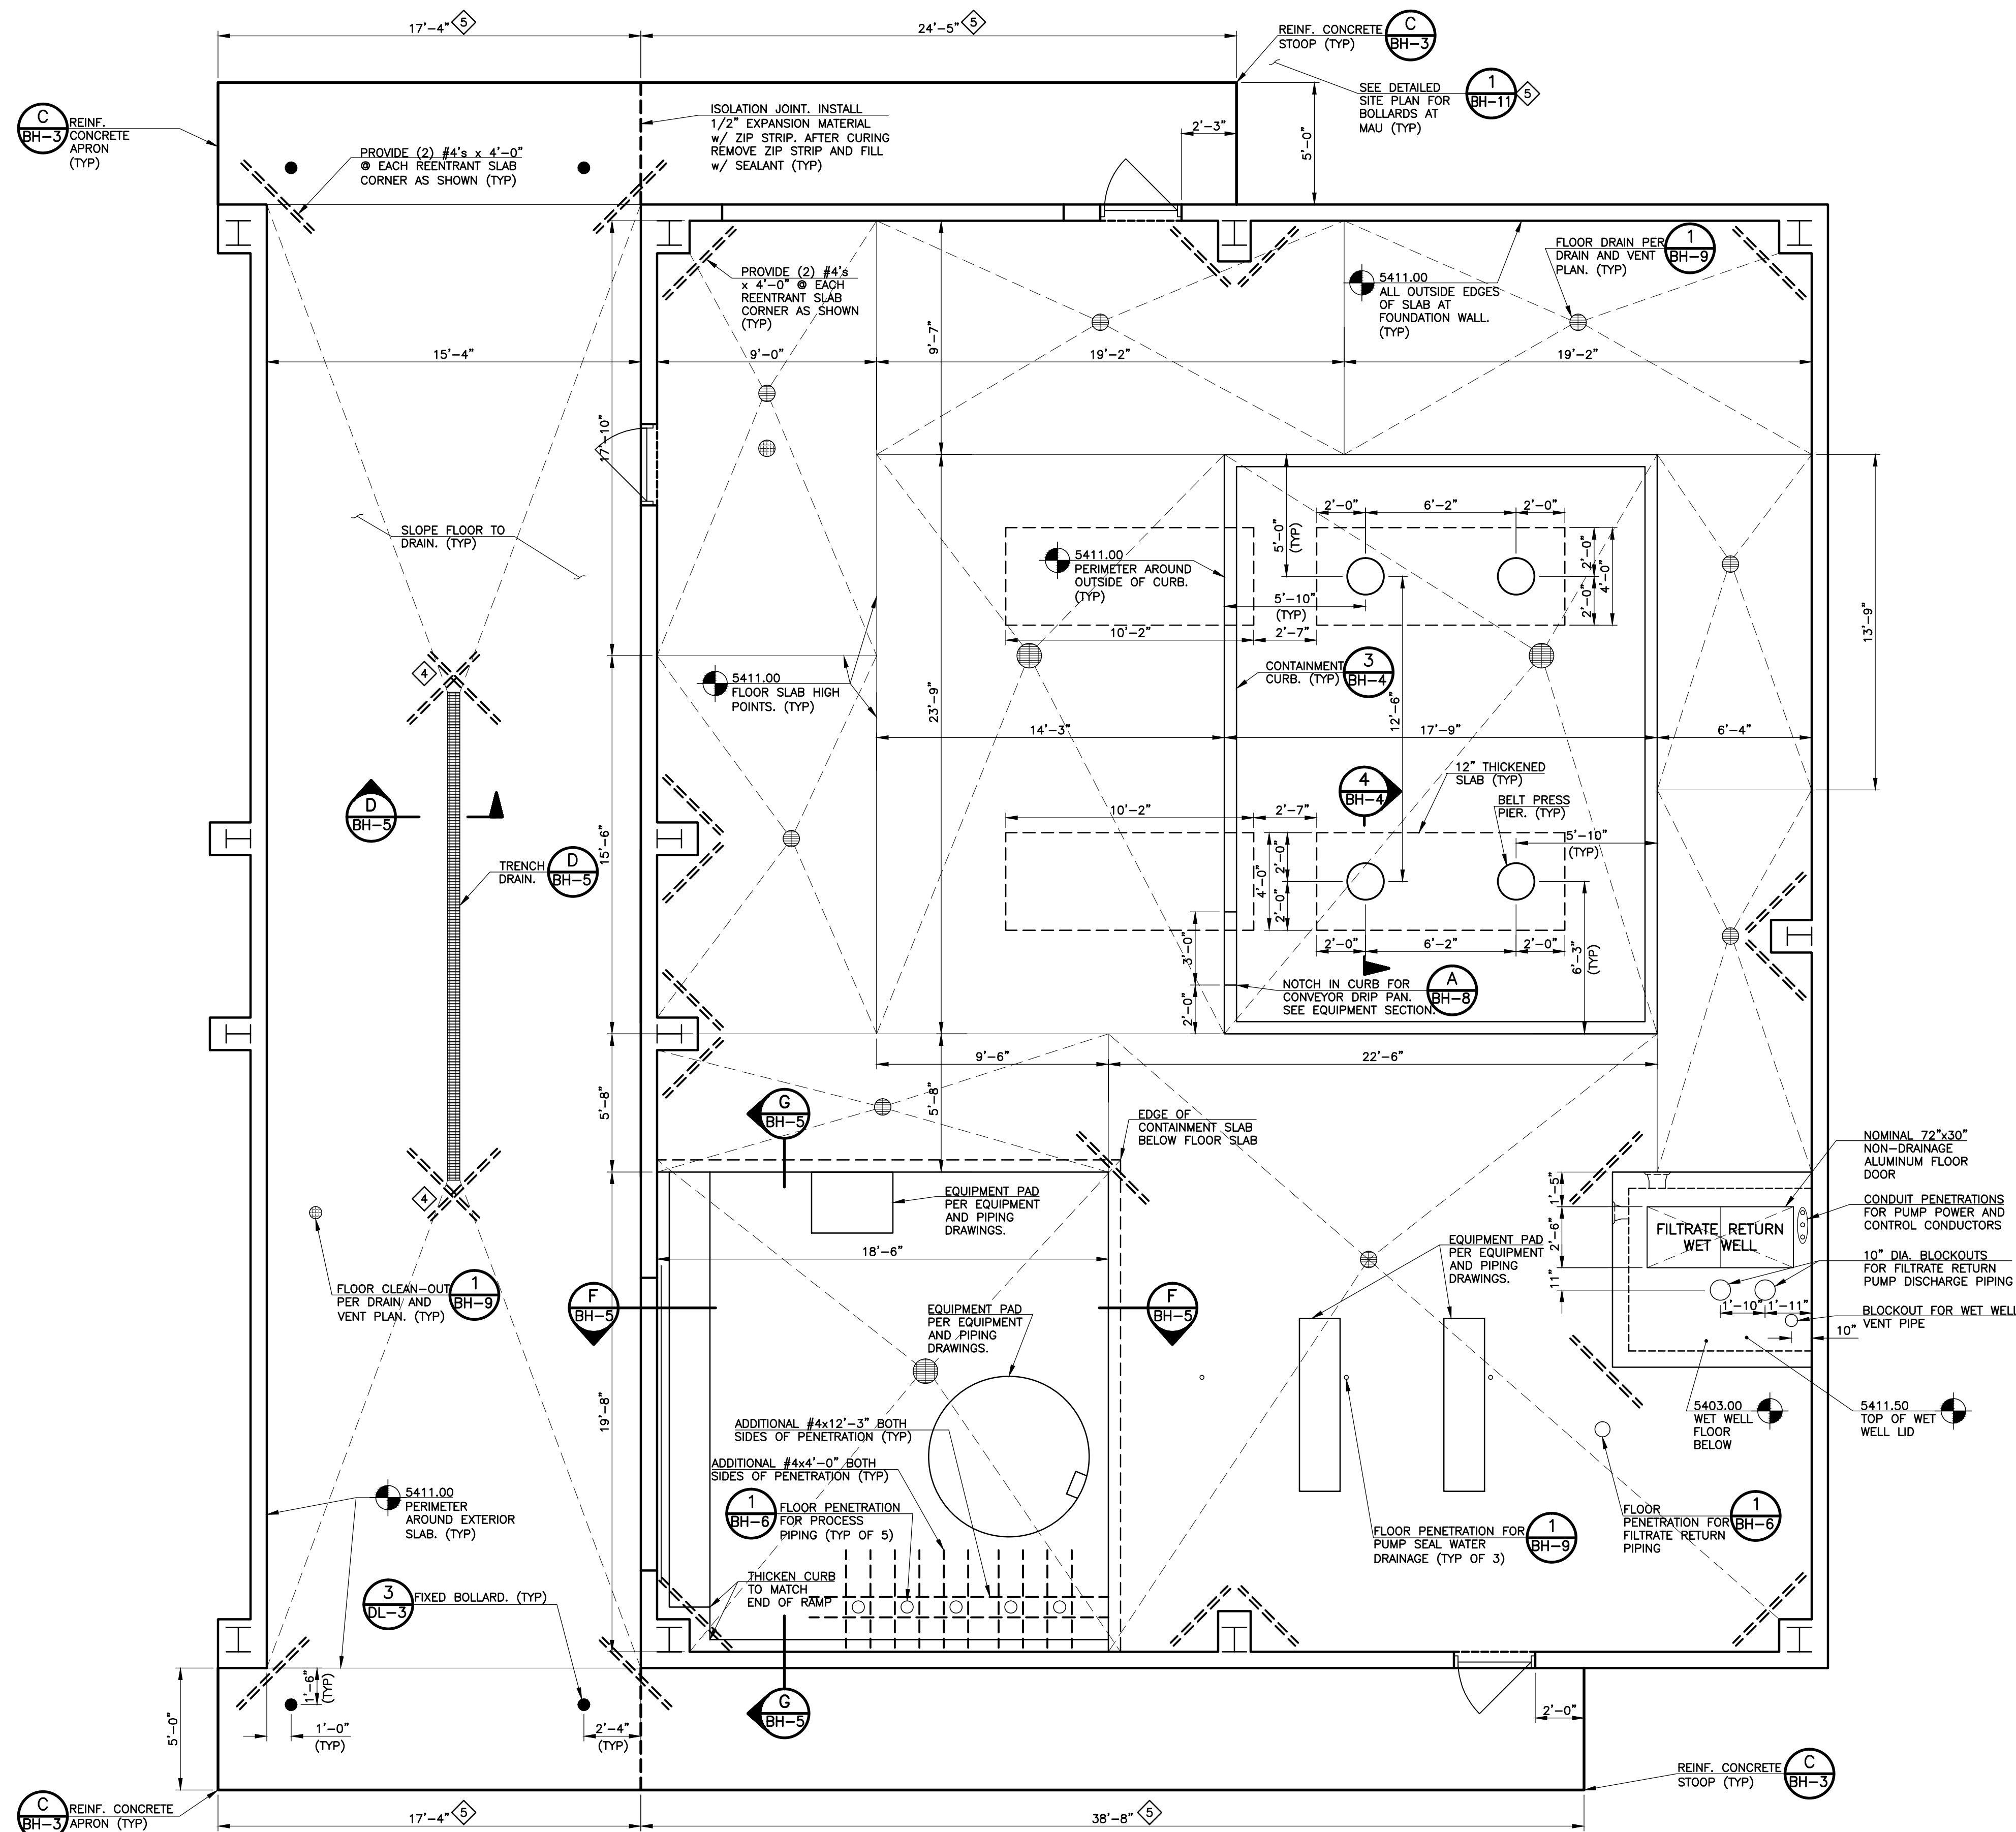


1 STRUCTURAL FLOOR PLAN
BH-4 SCALE: 1/4" = 1'-0"


2 TYPICAL SLAB DETAIL
BH-4 SCALE: NONE

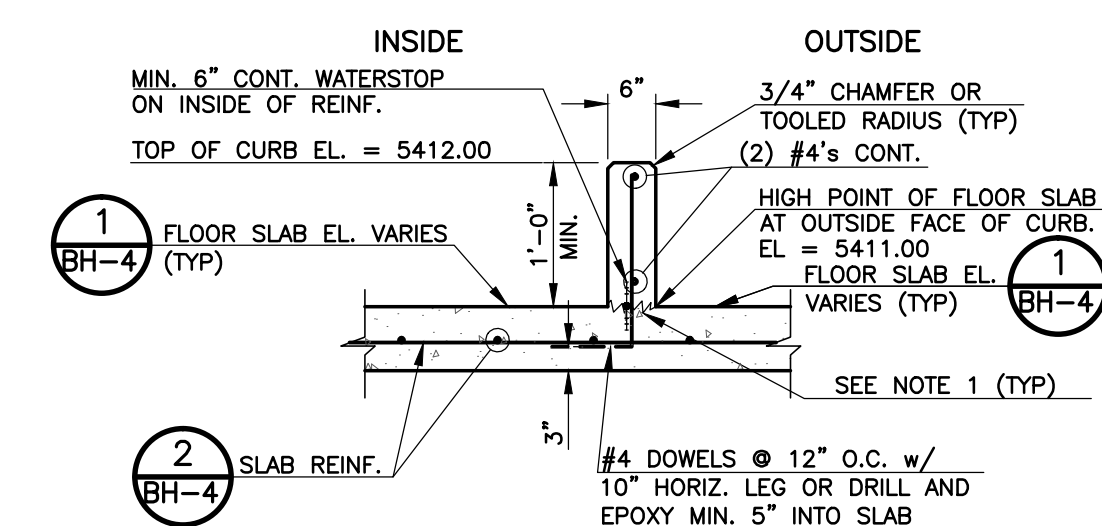

3 **CONTAINMENT CURB DETAIL**
BH-4 SCALE: 1/2" = 1'-0"

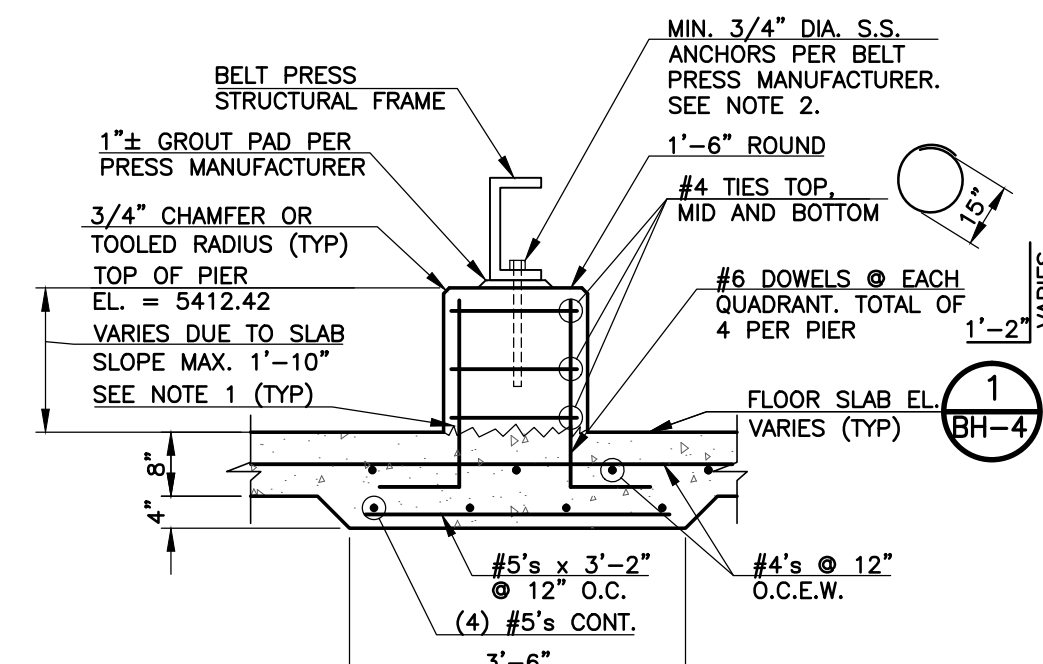

4 BELT PRESS PIER DETAIL
BH-4 SCALE: 1/2" = 1'-0"

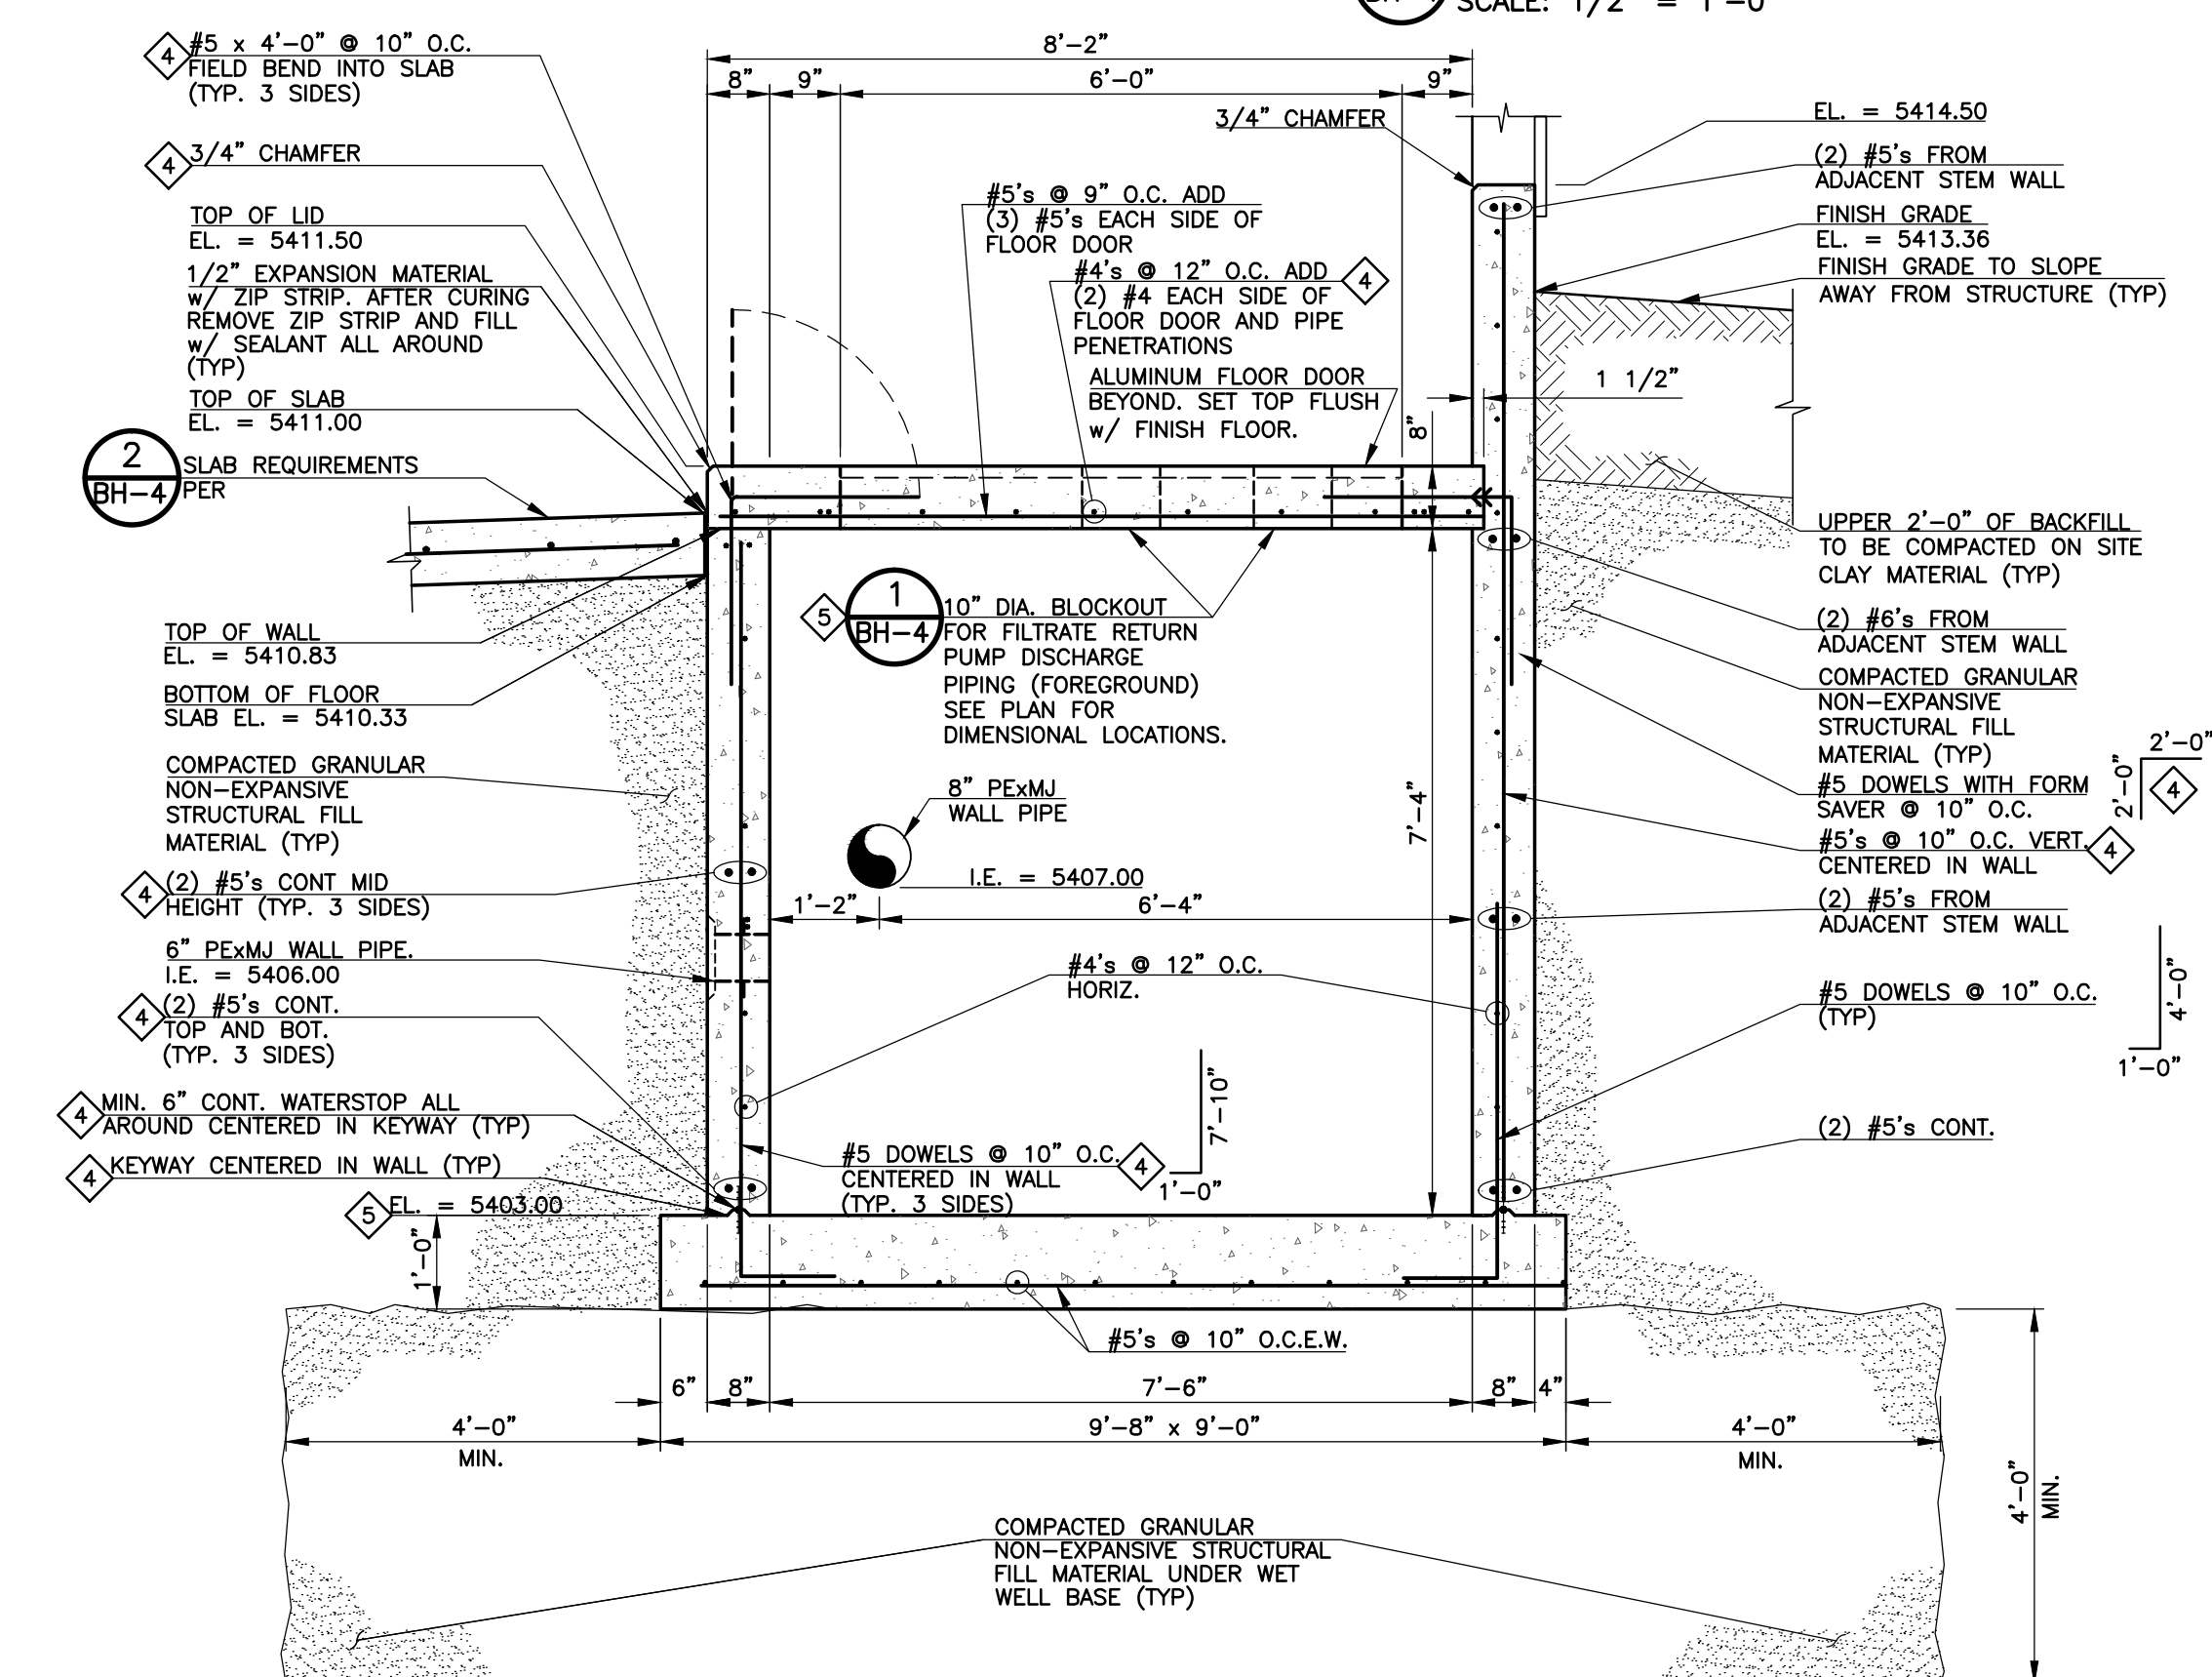

WET WELL DETAIL
SCALE: 1/2" = 1'-0"

SHEET NOTES:

1. CONTRACTOR SHALL VERIFY ALL EQUIPMENT PAD LOCATIONS AND DIMENSIONS WITH APPROVED SHOP SUBMITTAL DOCUMENTS FOR EQUIPMENT PROVIDED.
2. REFER TO DRAIN AND VENT PLAN AND EQUIPMENT AND PIPING DRAWINGS FOR UNDER SLAB PIPING REQUIREMENTS.
3. INTERIOR AND EXTERIOR SLABS ARE 8" MINIMUM THICKNESS REINFORCED WITH #4s @ 12" O.C., CENTERED IN SLAB, ON 4 FEET OF SELECT COMPACTED STRUCTURAL FILL.
4. REFER TO ELECTRICAL DRAWINGS FOR UNDER SLAB CONDUIT REQUIREMENTS.

[illegible]

THIS DRAWING IS THE PROPERTY OF GMS, INC., AND IS NOT TO BE REPRODUCED, MODIFIED OR USED FOR ANY OTHER PROJECT OR EXTENSION OF THIS PROJECT EXCEPT BY AGREEMENT WITH THIS COMPANY.

DRAWN	SKC
DESIGNED	MAM
CHECKED	RJS
DATE	SEPTEMBER 2012
PROJECT NO.	20166.382
GMS FILE NO.	2599

STRUCTURAL FLOOR PLAN

HAROLD D. THOMPSON REGIONAL WATER RECLAMATION FACILITY

LOWER FOUNTAIN METROPOLITAN SEWAGE DISPOSAL DISTRICT

GMS, INC.
CONSULTING ENGINEERS
611 N. WEBER, SUITE 300
COLORADO SPRINGS, COLORADO 80903

SHEET
BH-4
OF
—