


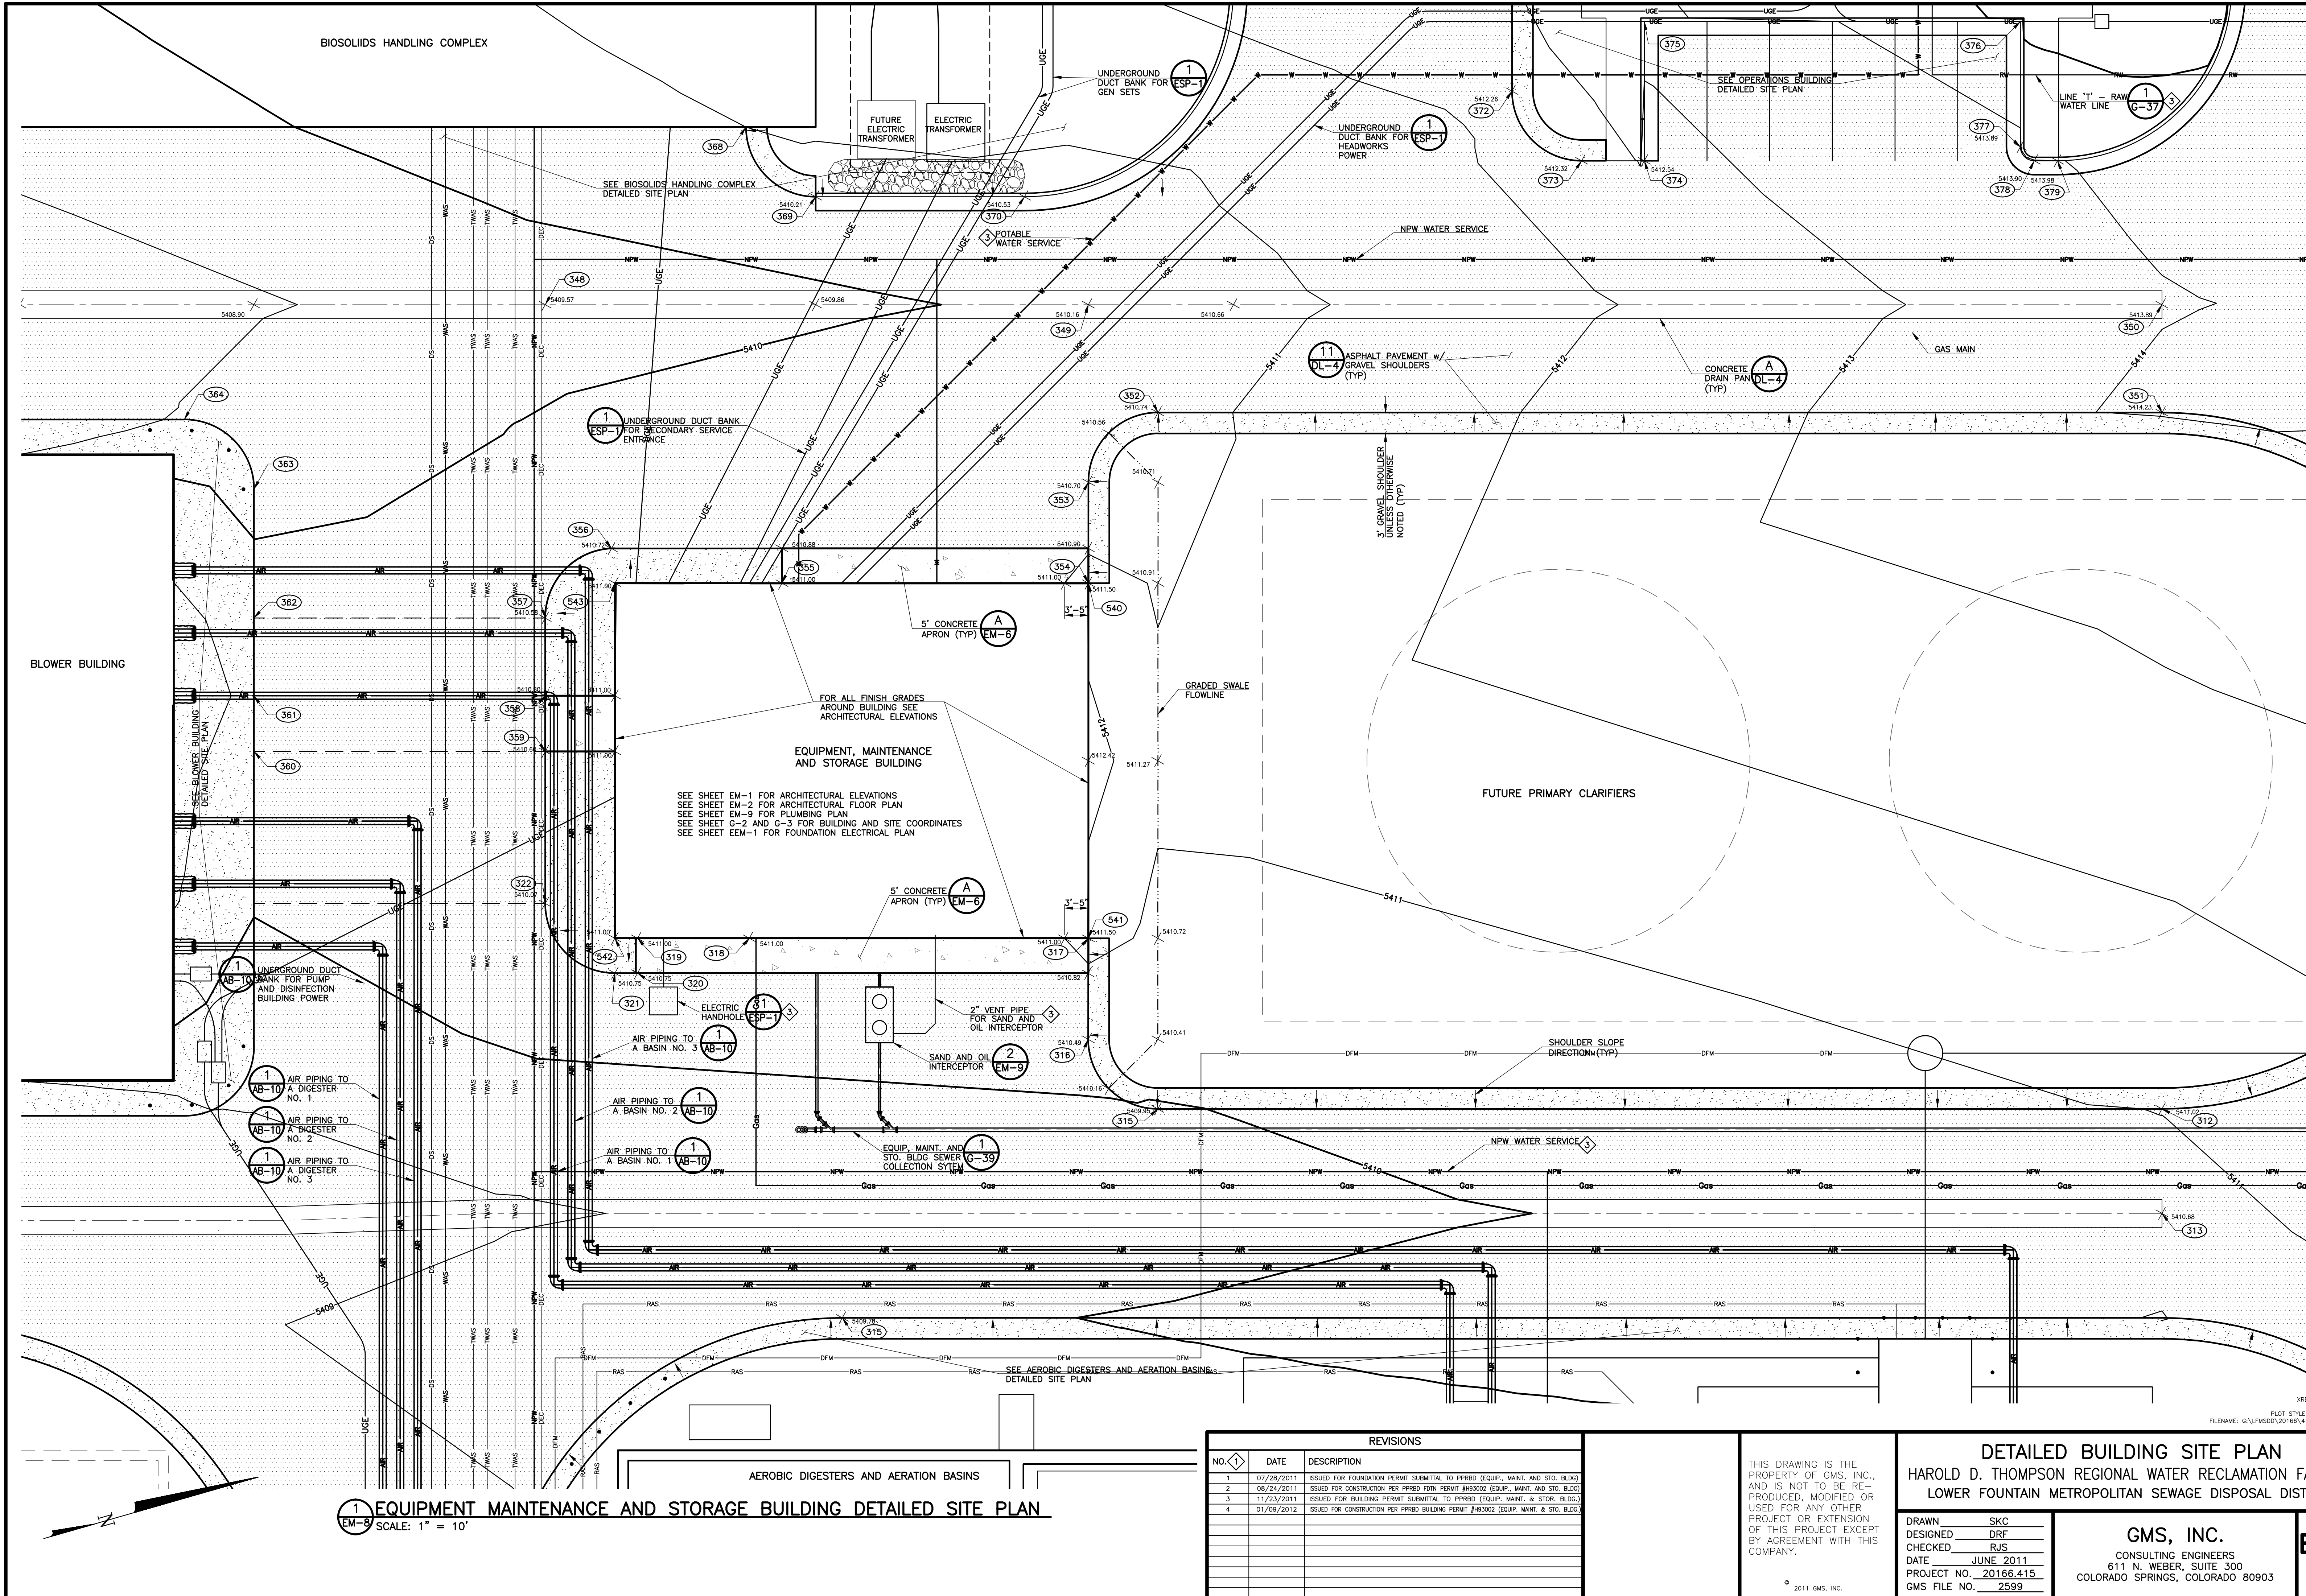

1 EQUIPMENT MAINTENANCE AND STORAGE BUILDING DETAILED SITE PLAN
EM-8 SCALE: 1" = 10'

REVISIONS		
NO.	DATE	DESCRIPTION
1	07/28/2011	ISSUED FOR FOUNDATION PERMIT SUBMITTAL TO PPRBD (EQUIP., MAINT. AND STO. BLDG.)
2	08/24/2011	ISSUED FOR CONSTRUCTION PER PPRBD (EQUIP., MAINT. AND STO. BLDG.)
3	11/23/2011	ISSUED FOR BUILDING PERMIT SUBMITTAL TO PPRBD (EQUIP., MAINT. & STO. BLDG.)
4	01/09/2012	ISSUED FOR CONSTRUCTION PER PPRBD BUILDING PERMIT #H3002 (EQUIP., MAINT. & STO. BLDG.)

THIS DRAWING IS THE PROPERTY OF GMS, INC., AND IS NOT TO BE REPRODUCED, MODIFIED OR USED FOR ANY OTHER PROJECT OR EXTENSION OF THIS PROJECT EXCEPT BY AGREEMENT WITH THIS COMPANY.

DETAILED BUILDING SITE PLAN

HAROLD D. THOMPSON REGIONAL WATER RECLAMATION FACILITY

LOWER FOUNTAIN METROPOLITAN SEWAGE DISPOSAL DISTRICT

DRAWN

DESIGNED

CHECKED

DATE

PROJECT NO.

GMS FILE NO.

SKC

DRF

RJS

JUNE 2011

20166.415

2599

GMS, INC.

CONSULTING ENGINEERS

611 N. WEBER, SUITE 300

COLORADO SPRINGS, COLORADO 80903

SHEET

EM-8

OF

—

G:\ENR\2012\01\01\B145\B145.dwg, ENR, 1/26/2012 11:48:40 AM, sc, DWG To PDF, p3, 1, 1