
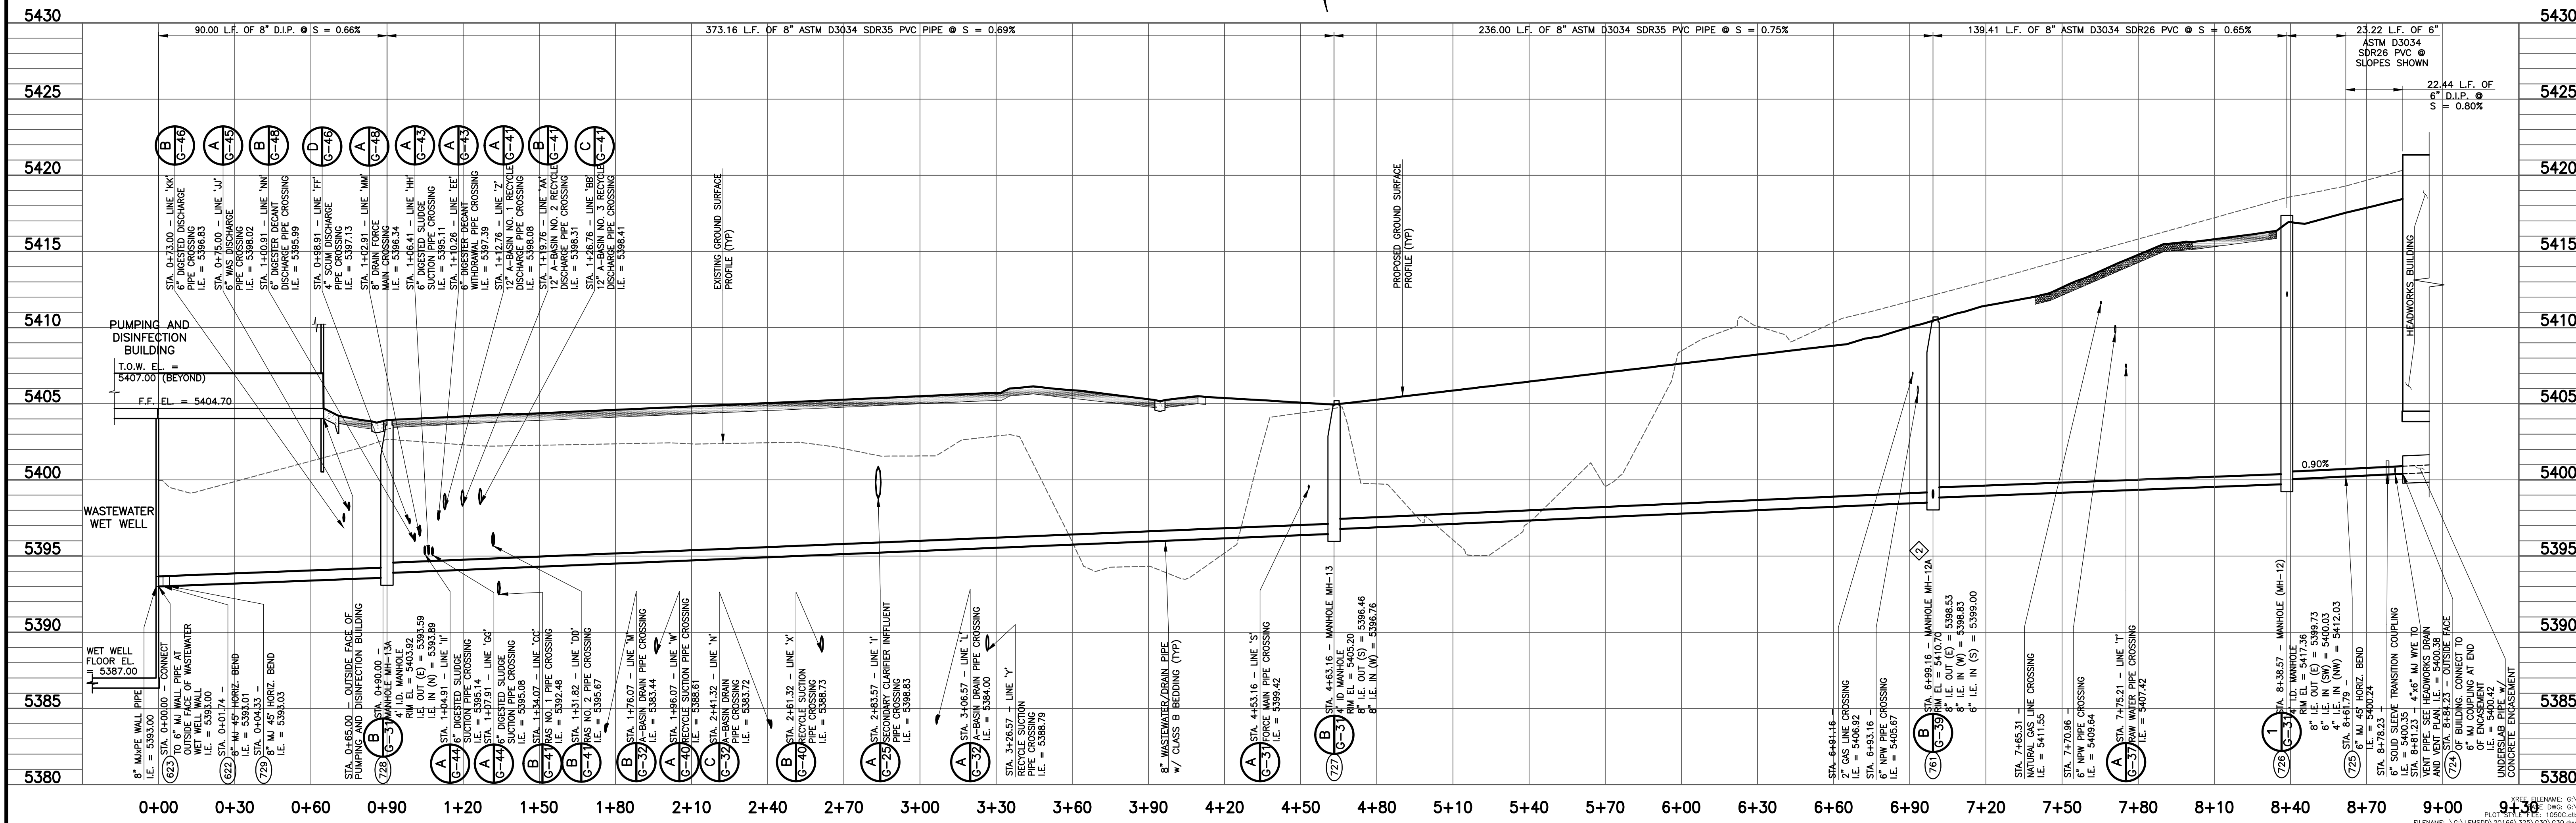


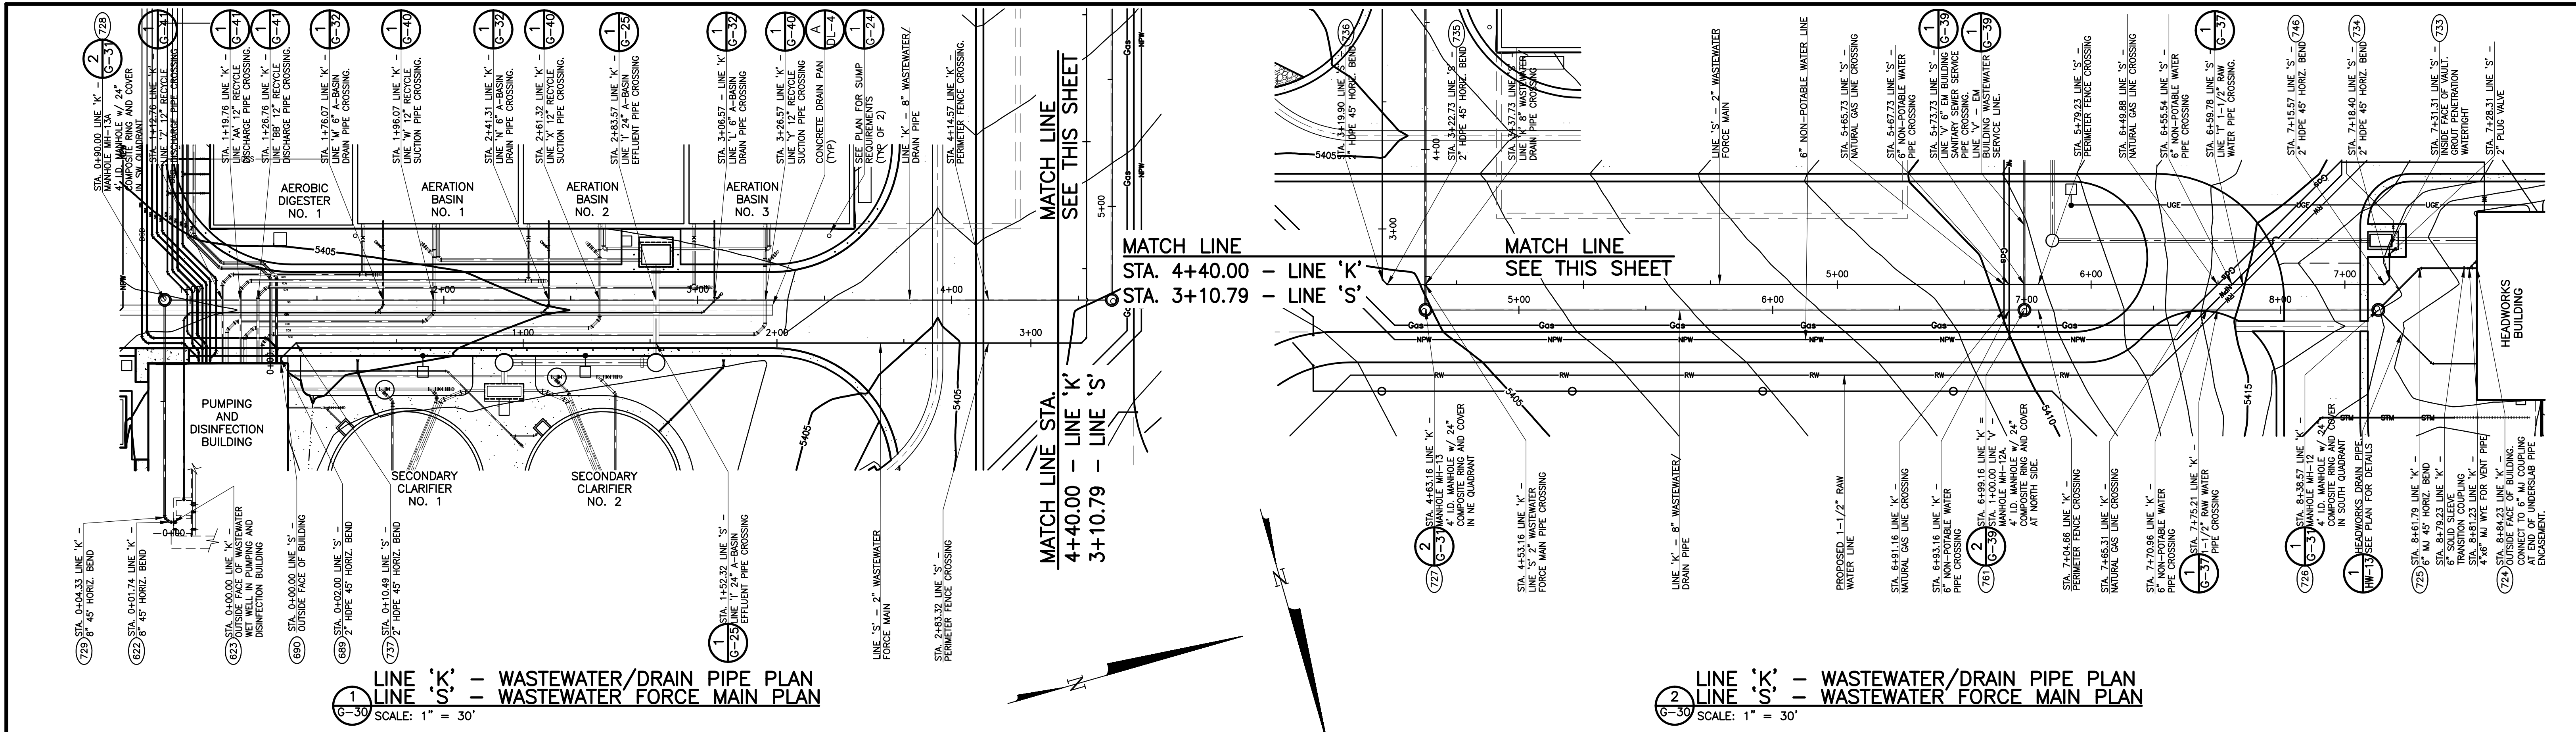

LINE 'K' WASTEWATER/DRAIN PIPE PROFILE
SCALE: HORIZ. 1" = 30' VERT. 1" = 5'

REVISIONS		
NO.	DATE	DESCRIPTION
1	03/08/2012	ISSUED FOR CONSTRUCTION
2	04/27/2012	SHOP SUBMITTAL NO. 02709-006 COMMENTS

THIS DRAWING IS THE PROPERTY OF GMS, INC., AND IS NOT TO BE RE-PRODUCED, MODIFIED OR USED FOR ANY OTHER PROJECT OR EXTENSION OF THIS PROJECT EXCEPT BY AGREEMENT WITH THIS COMPANY.

LINE 'K' - WASTEWATER/DRAIN PIPE PLAN AND PROFILE
LINE 'S' - WASTEWATER FORCE MAIN PLAN
HAROLD D. THOMPSON REGIONAL WATER RECLAMATION FACILITY
LOWER FOUNTAIN METROPOLITAN SEWAGE DISPOSAL DISTRICT

DRAWN: SKC
DESIGNED: MAM
CHECKED: RJS
DATE: 2011
PROJECT NO.: 20166.325
GMS FILE NO.: 2599

GMS, INC.
CONSULTING ENGINEERS
611 N. WEBER, SUITE 300
COLORADO SPRINGS, COLORADO 80903

SHEET
G-30
OF
1