




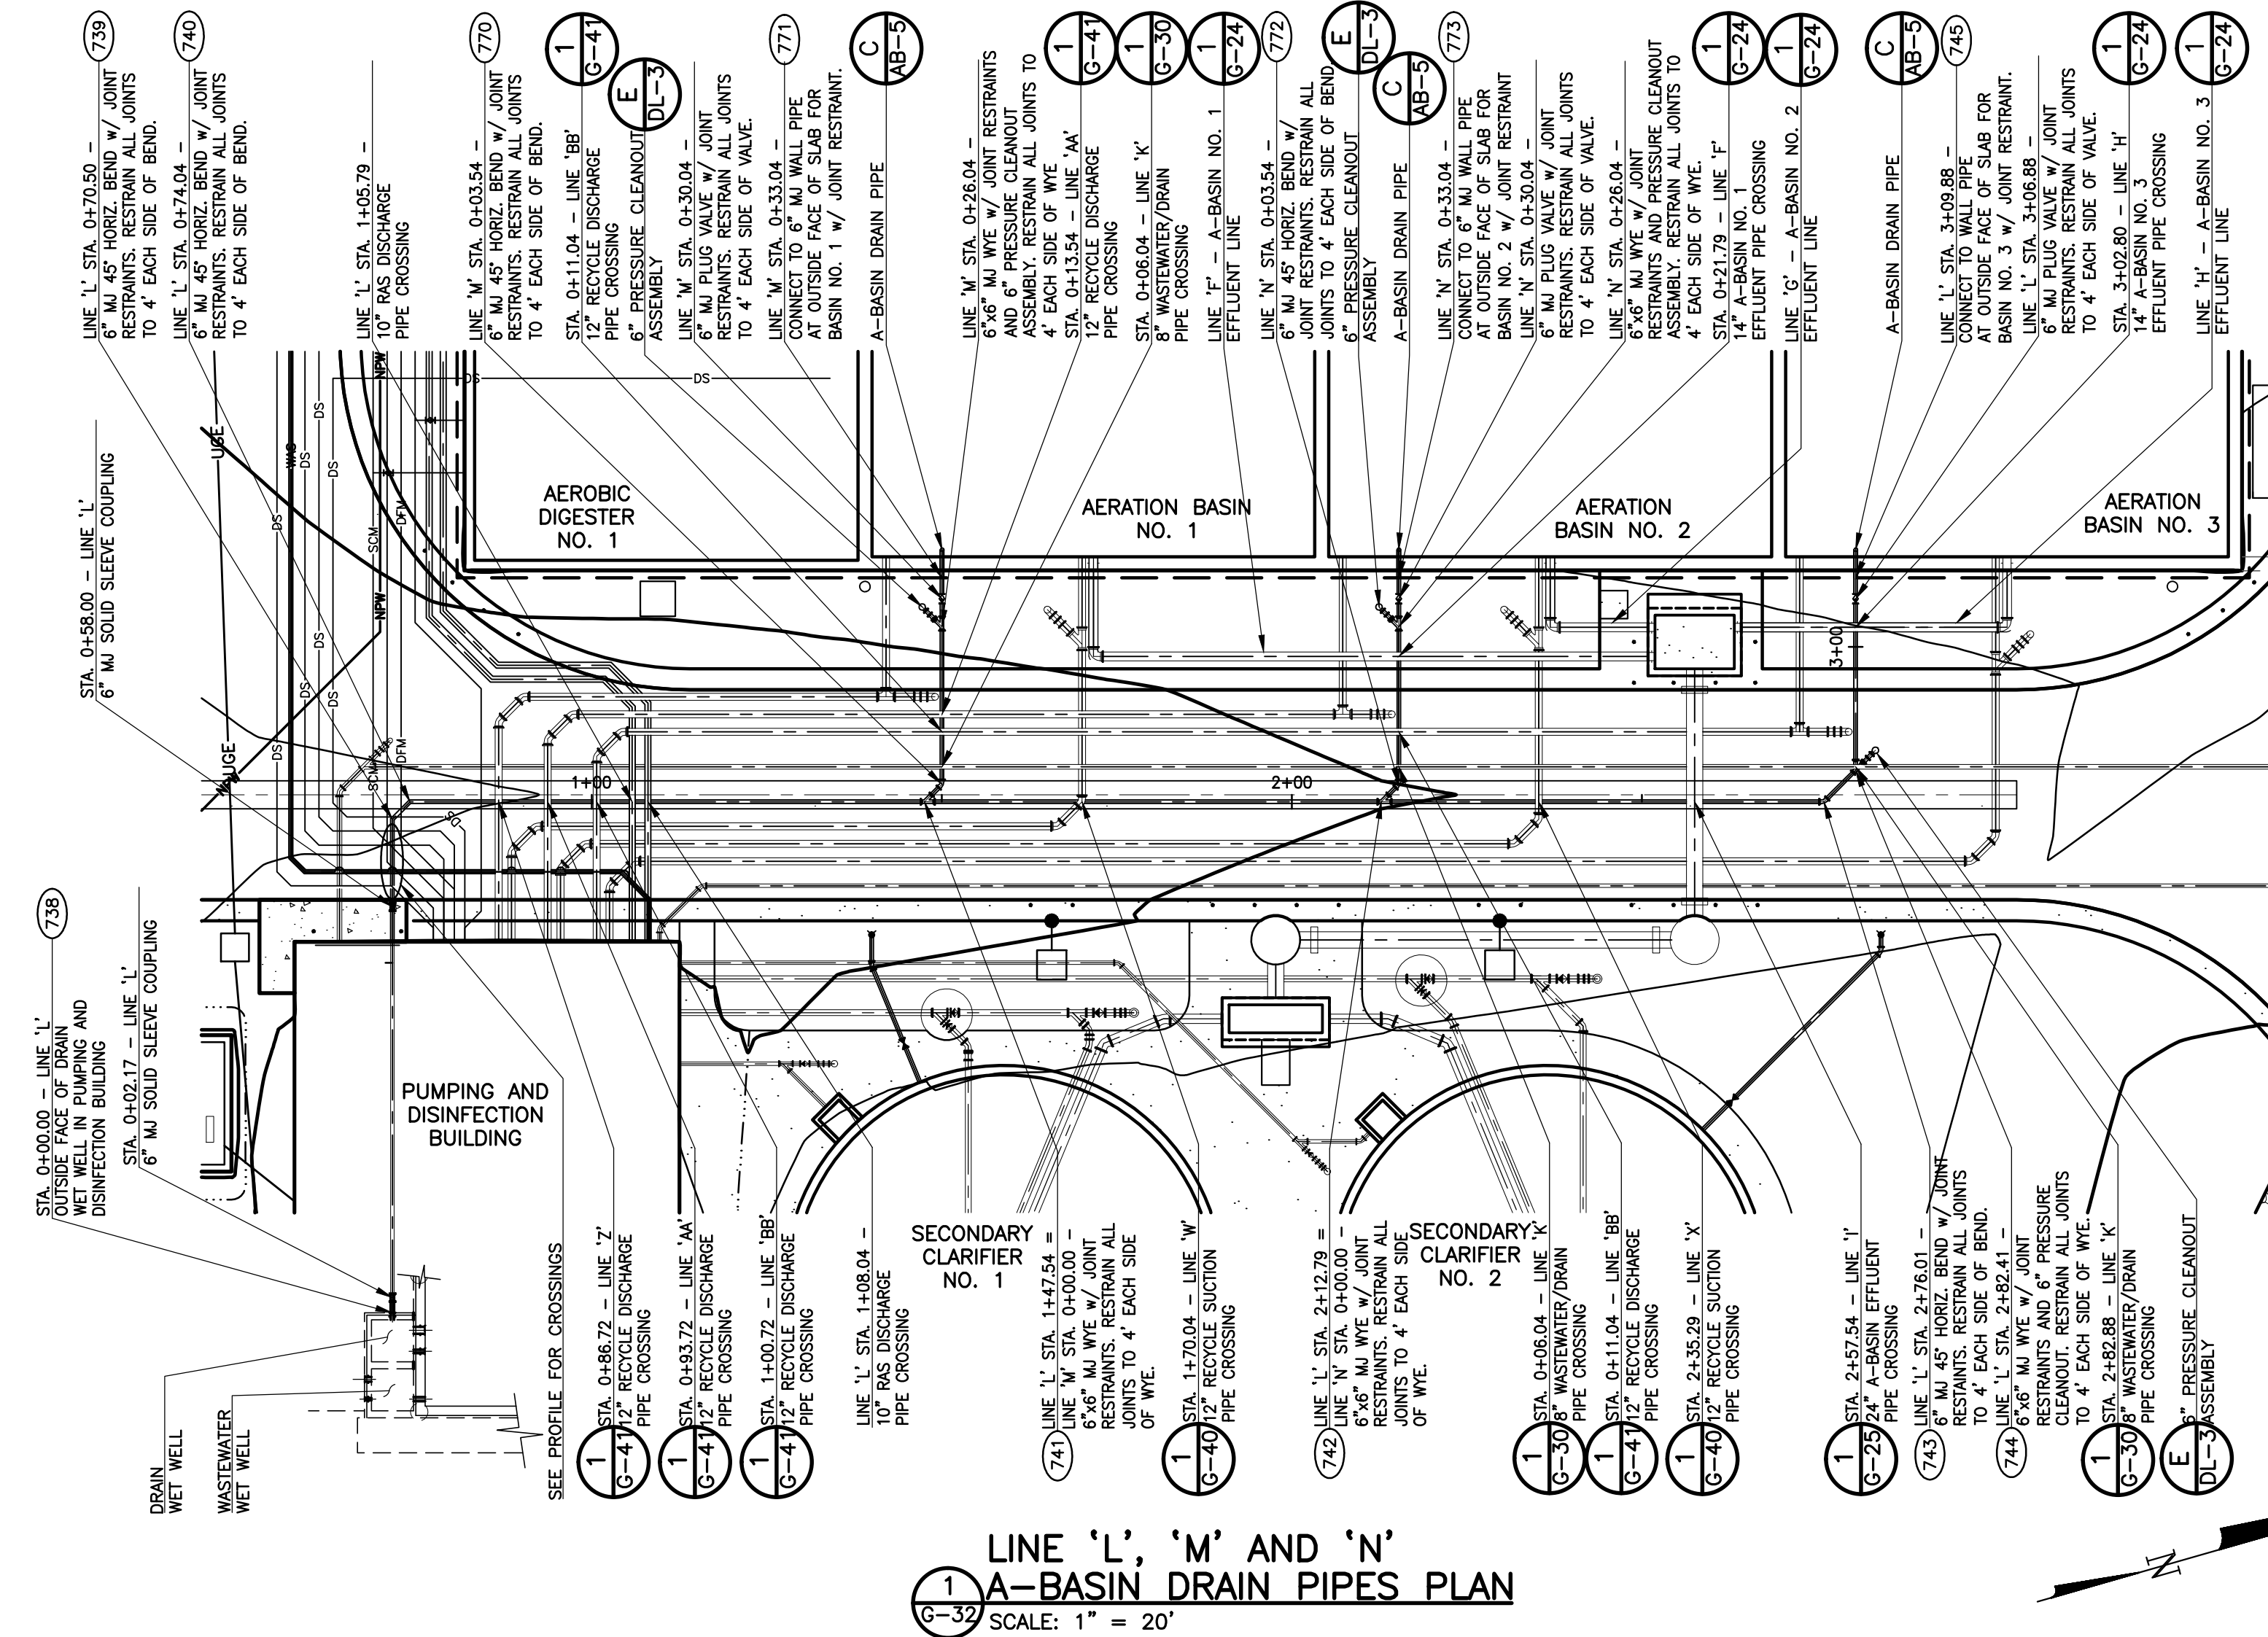


LINE 'L', 'M' AND 'N'
A-BASIN DRAIN PIPES PLAN
SCALE: 1" = 20'

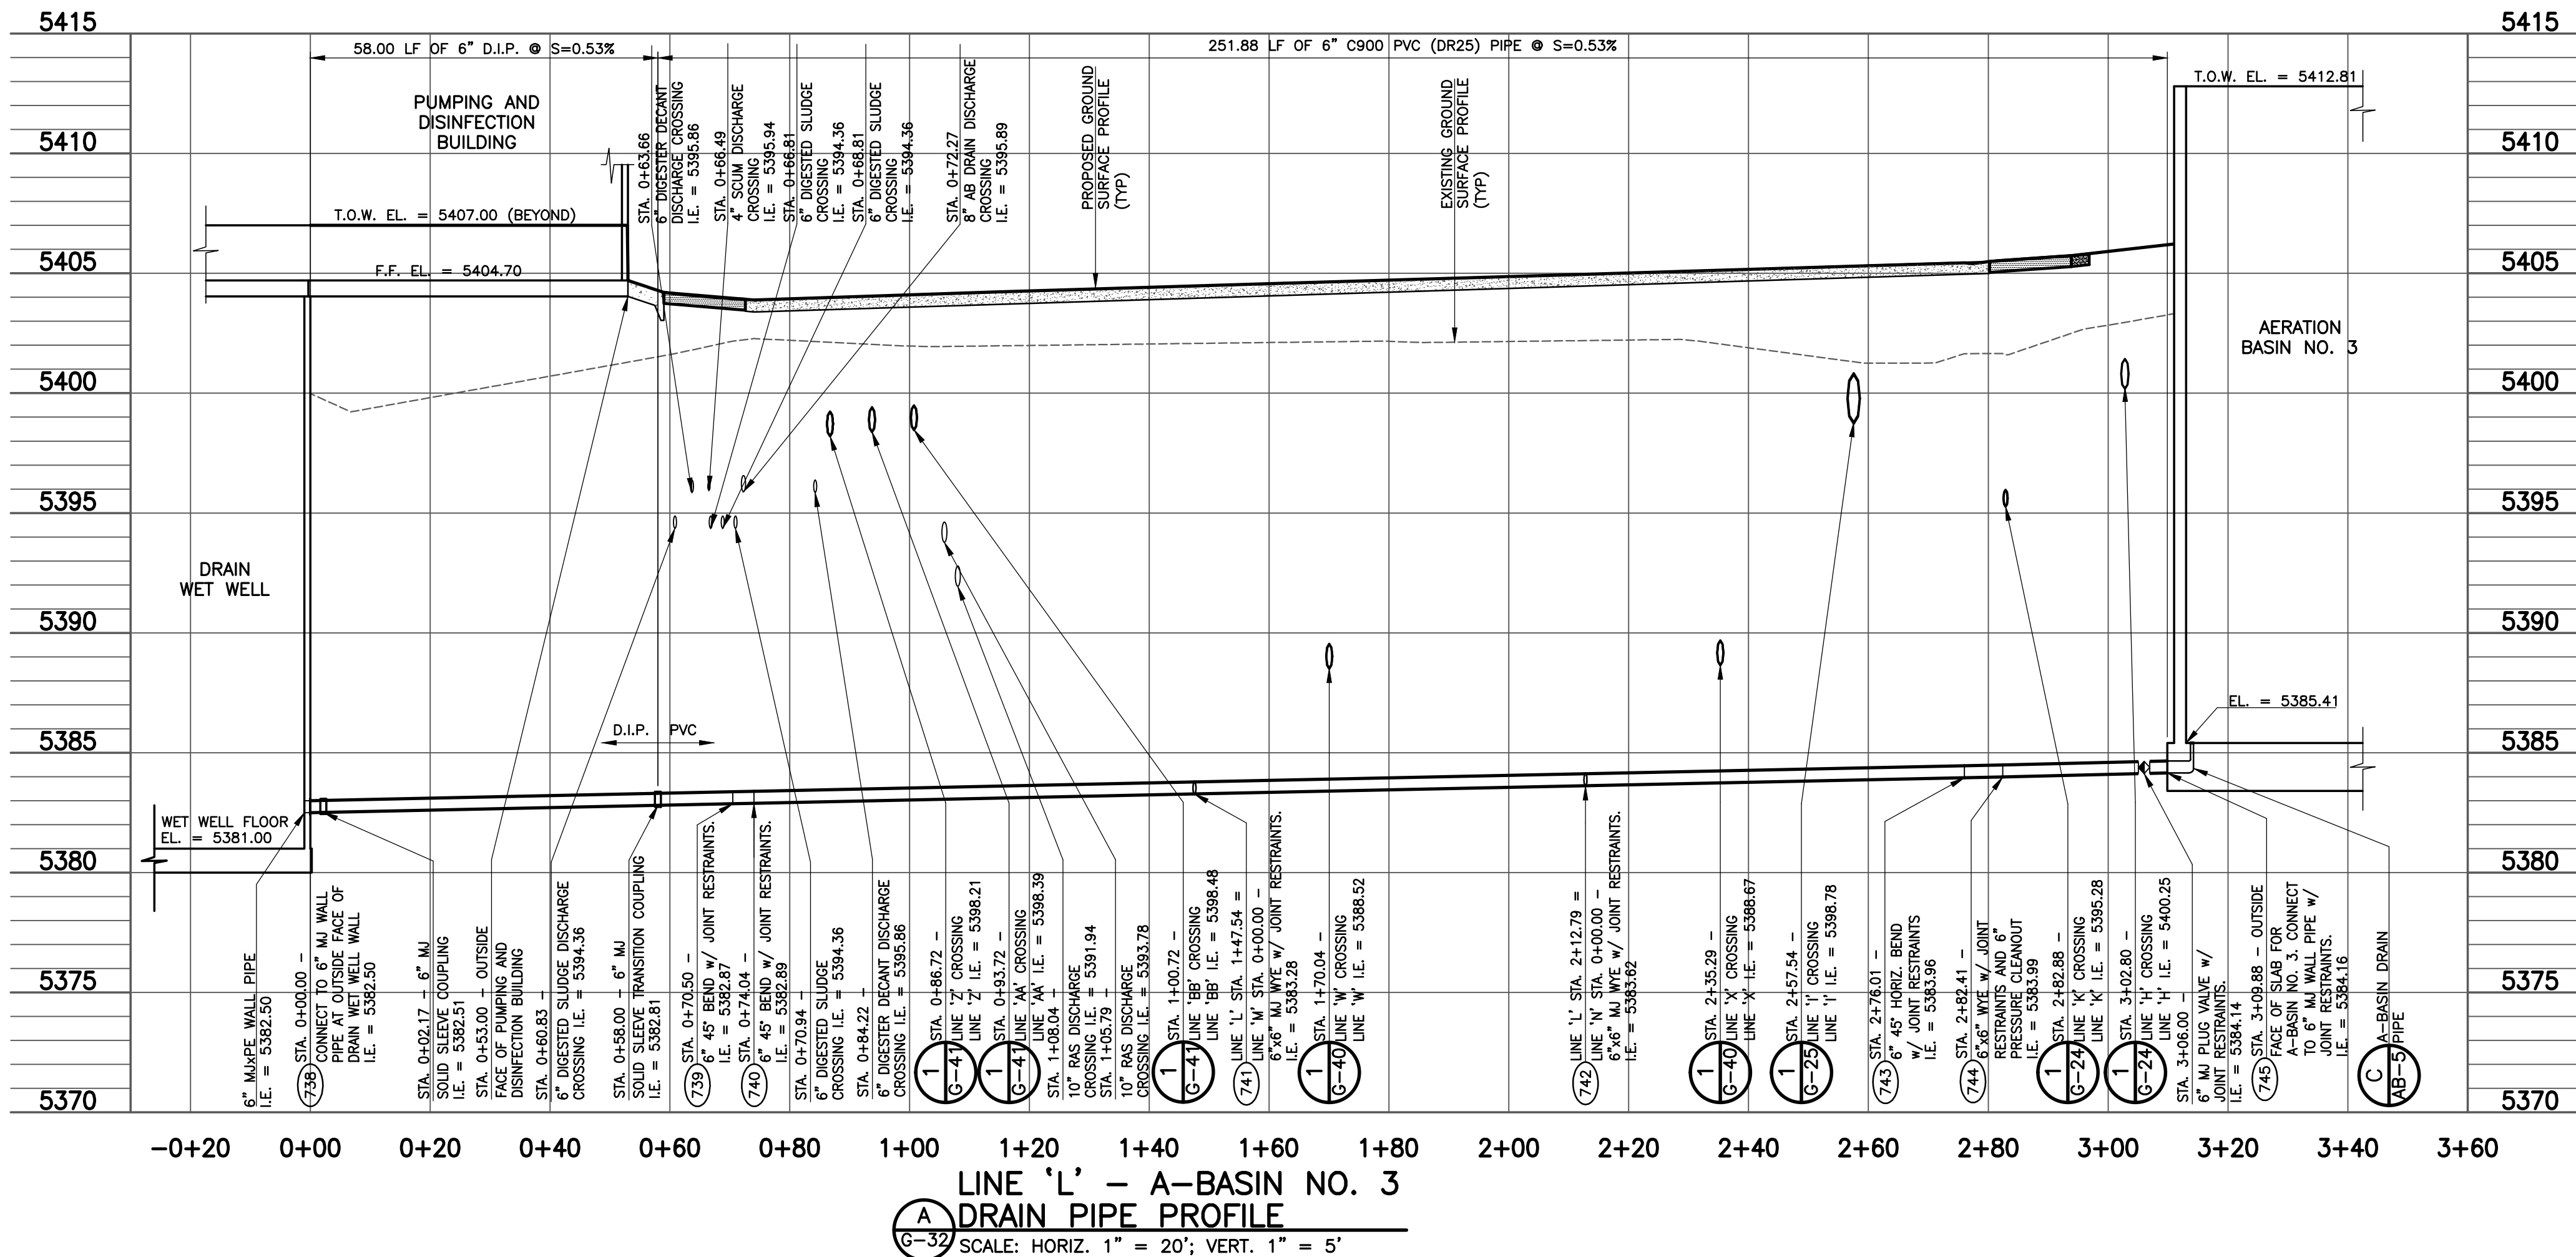

LINE 'L' - A-BASIN NO. 3
DRAIN PIPE PROFILE
SCALE: HORIZ. 1" = 20'; VERT. 1" = 5'

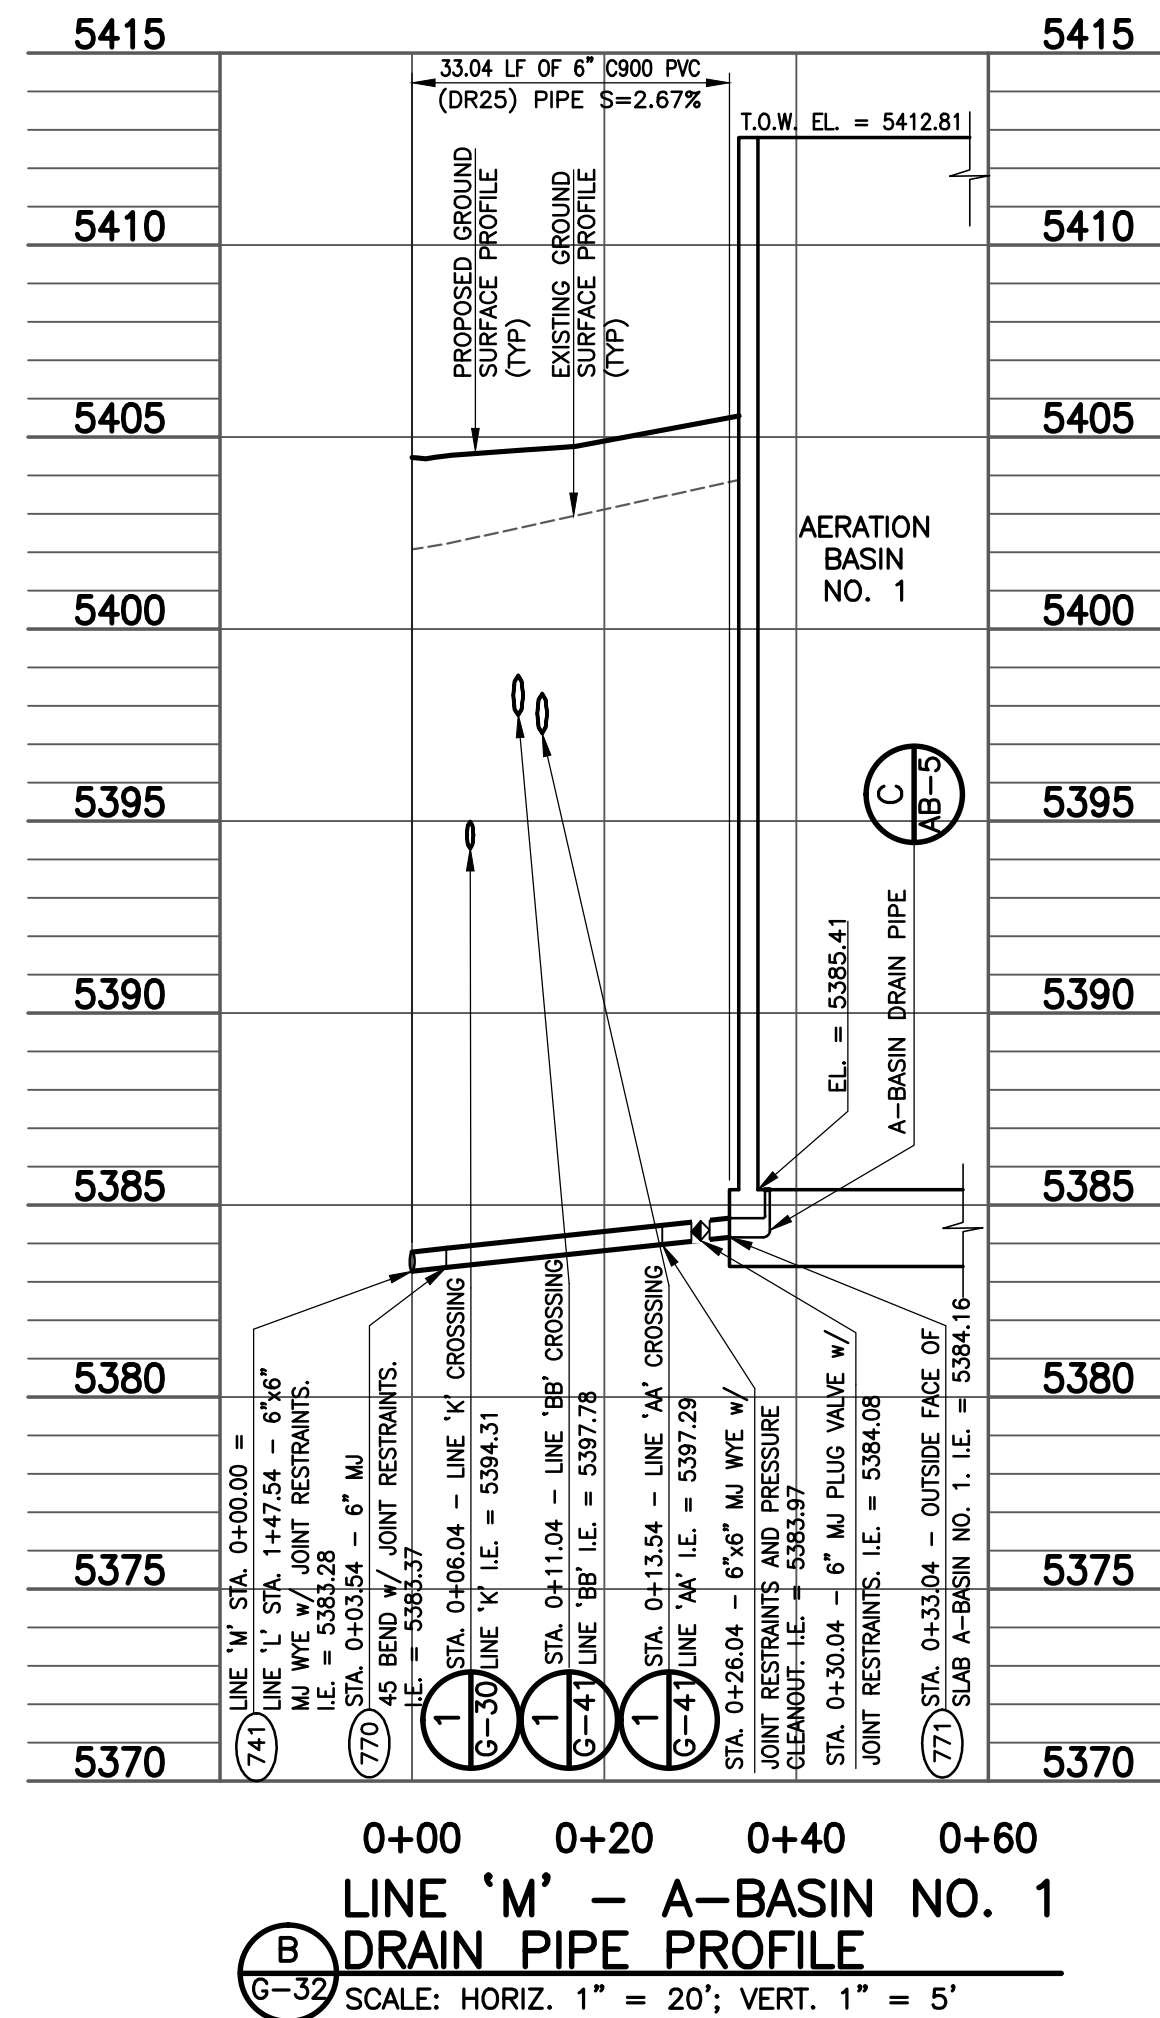

LINE 'M' - A-BASIN NO. 1
DRAIN PIPE PROFILE
SCALE: HORIZ. 1" = 20'; VERT. 1" = 5'

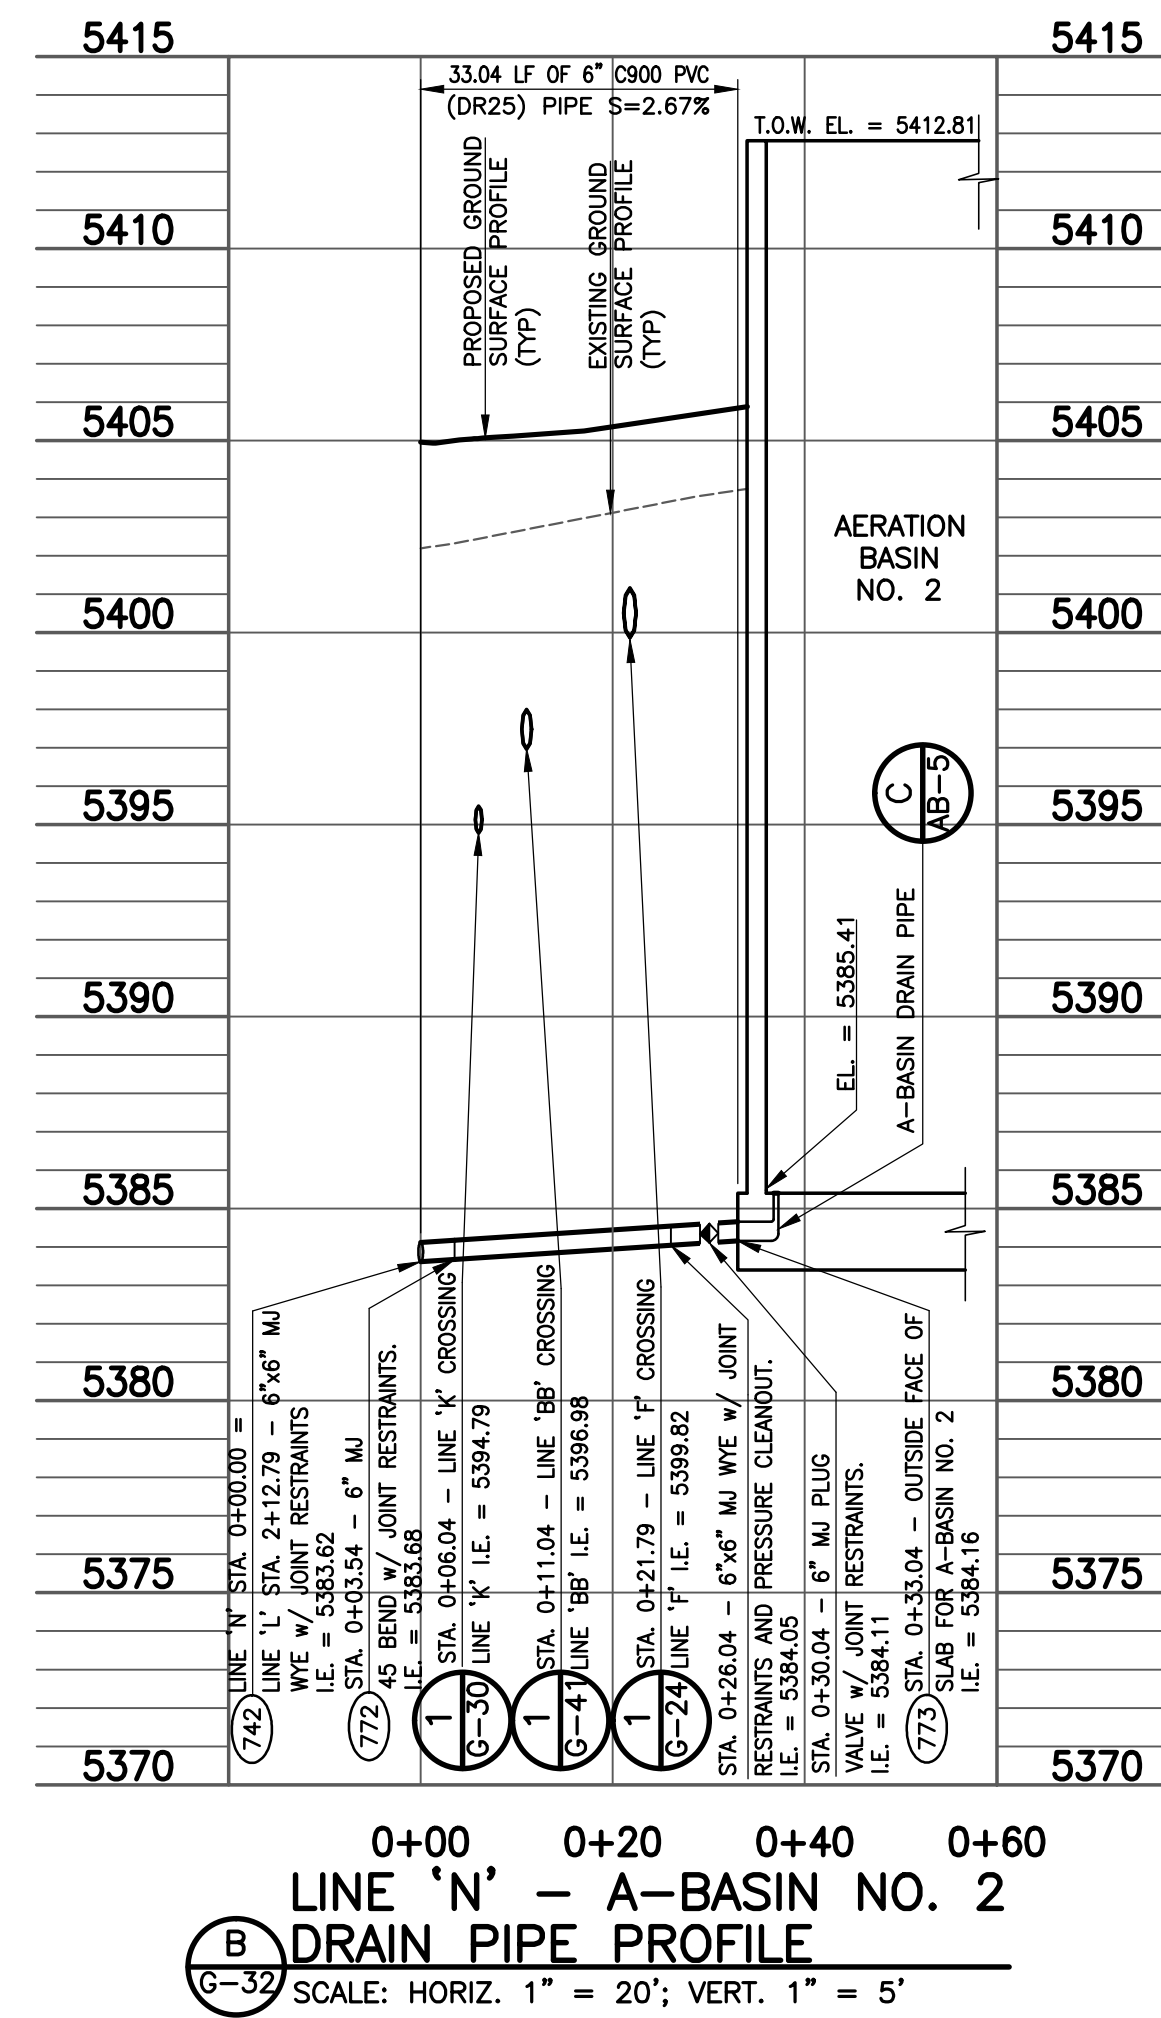

LINE 'N' - A-BASIN NO. 2
DRAIN PIPE PROFILE
SCALE: HORIZ. 1" = 20'; VERT. 1" = 5'

THIS DRAWING IS THE PROPERTY OF GMS, INC., AND IS NOT TO BE REPRODUCED, MODIFIED OR USED FOR ANY OTHER PROJECT OR EXTENSION OF THIS PROJECT EXCEPT BY AGREEMENT WITH THIS COMPANY.

LINE 'L', 'M' AND 'N' - A-BASIN DRAIN PIPES
PLAN AND PROFILES
HAROLD D. THOMPSON REGIONAL WATER RECLAMATION FACILITY
LOWER FOUNTAIN METROPOLITAN SEWAGE DISPOSAL DISTRICT

DRAWN SKC
DESIGNED MAM
CHECKED RJS
DATE 2011
PROJECT NO. 20166.325
GMS FILE NO. 2599

GMS, INC.
CONSULTING ENGINEERS
611 N. WEBER, SUITE 300
COLORADO SPRINGS, COLORADO 80903

SHEET
G-32
OF
1

XREF FILENAME: G:\
BASE DWG: G\1
PLOT STYLE FILE: 10302.ctb
FILENAME: G:\UNSWD00108\20166\20166.dwg