



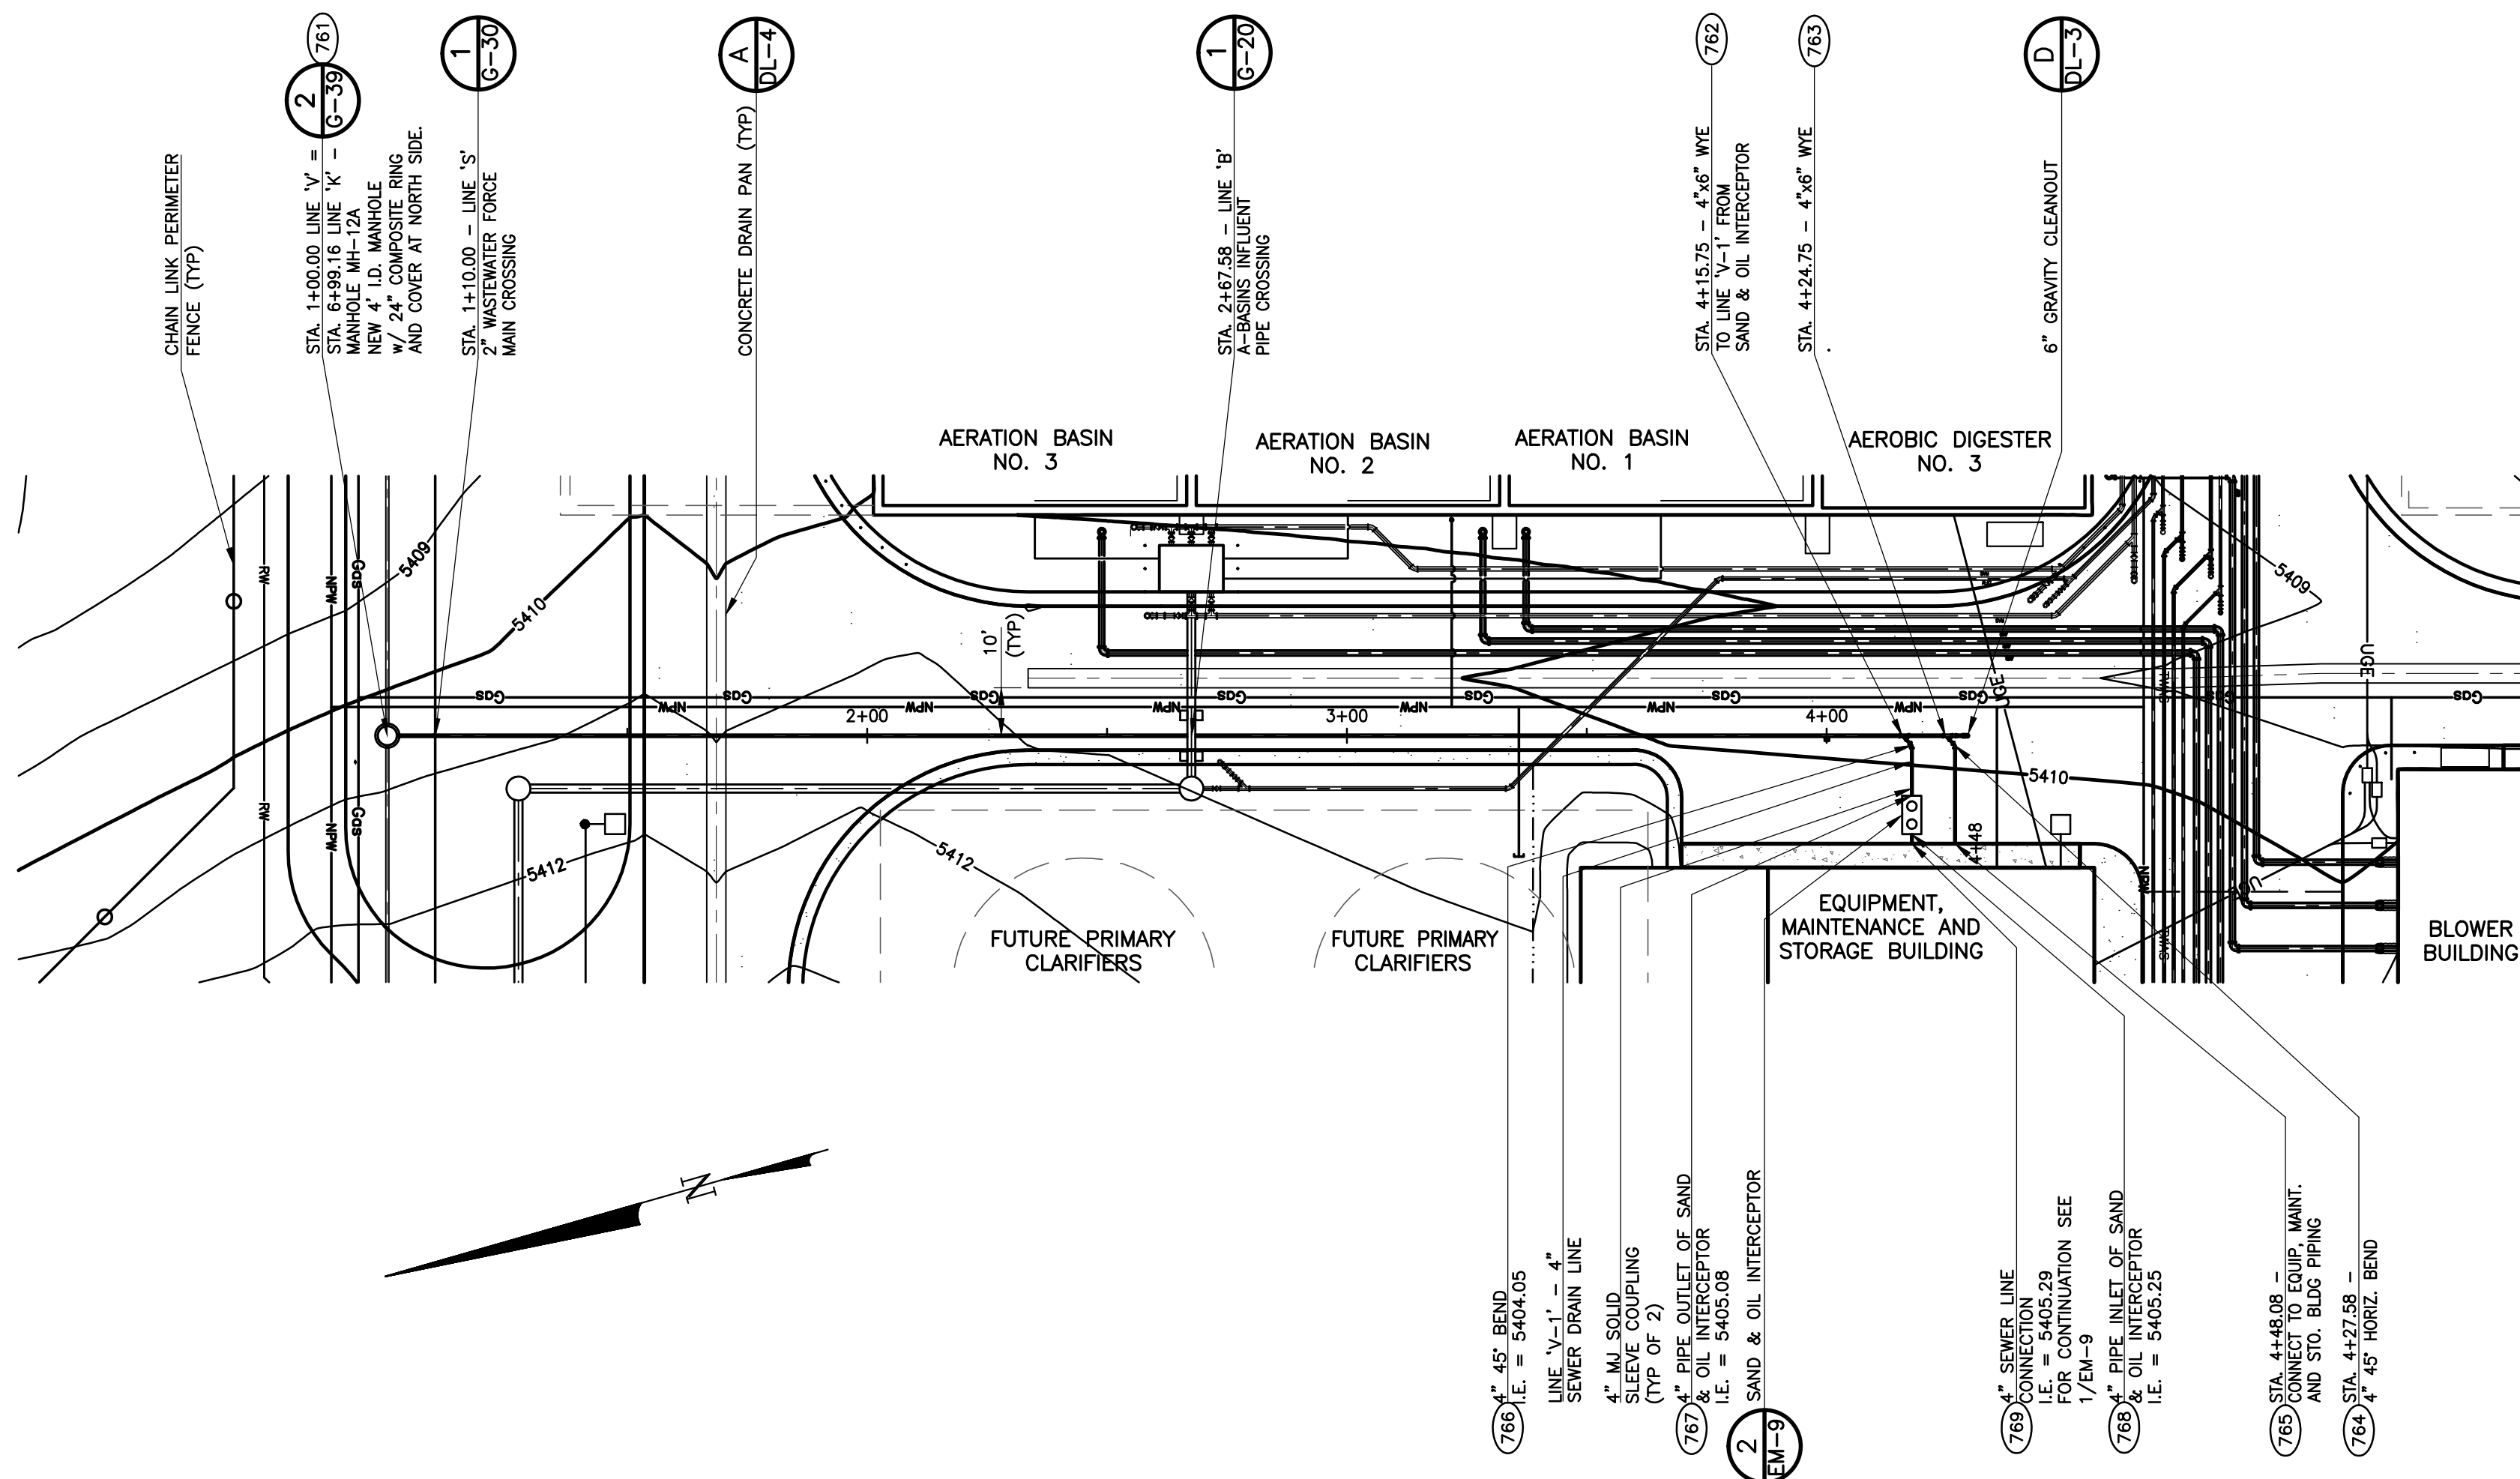


1 LINE 'V' - EM BUILDING SANITARY SEWER SERVICE LINE PLAN
 SCALE: 1" = 30'

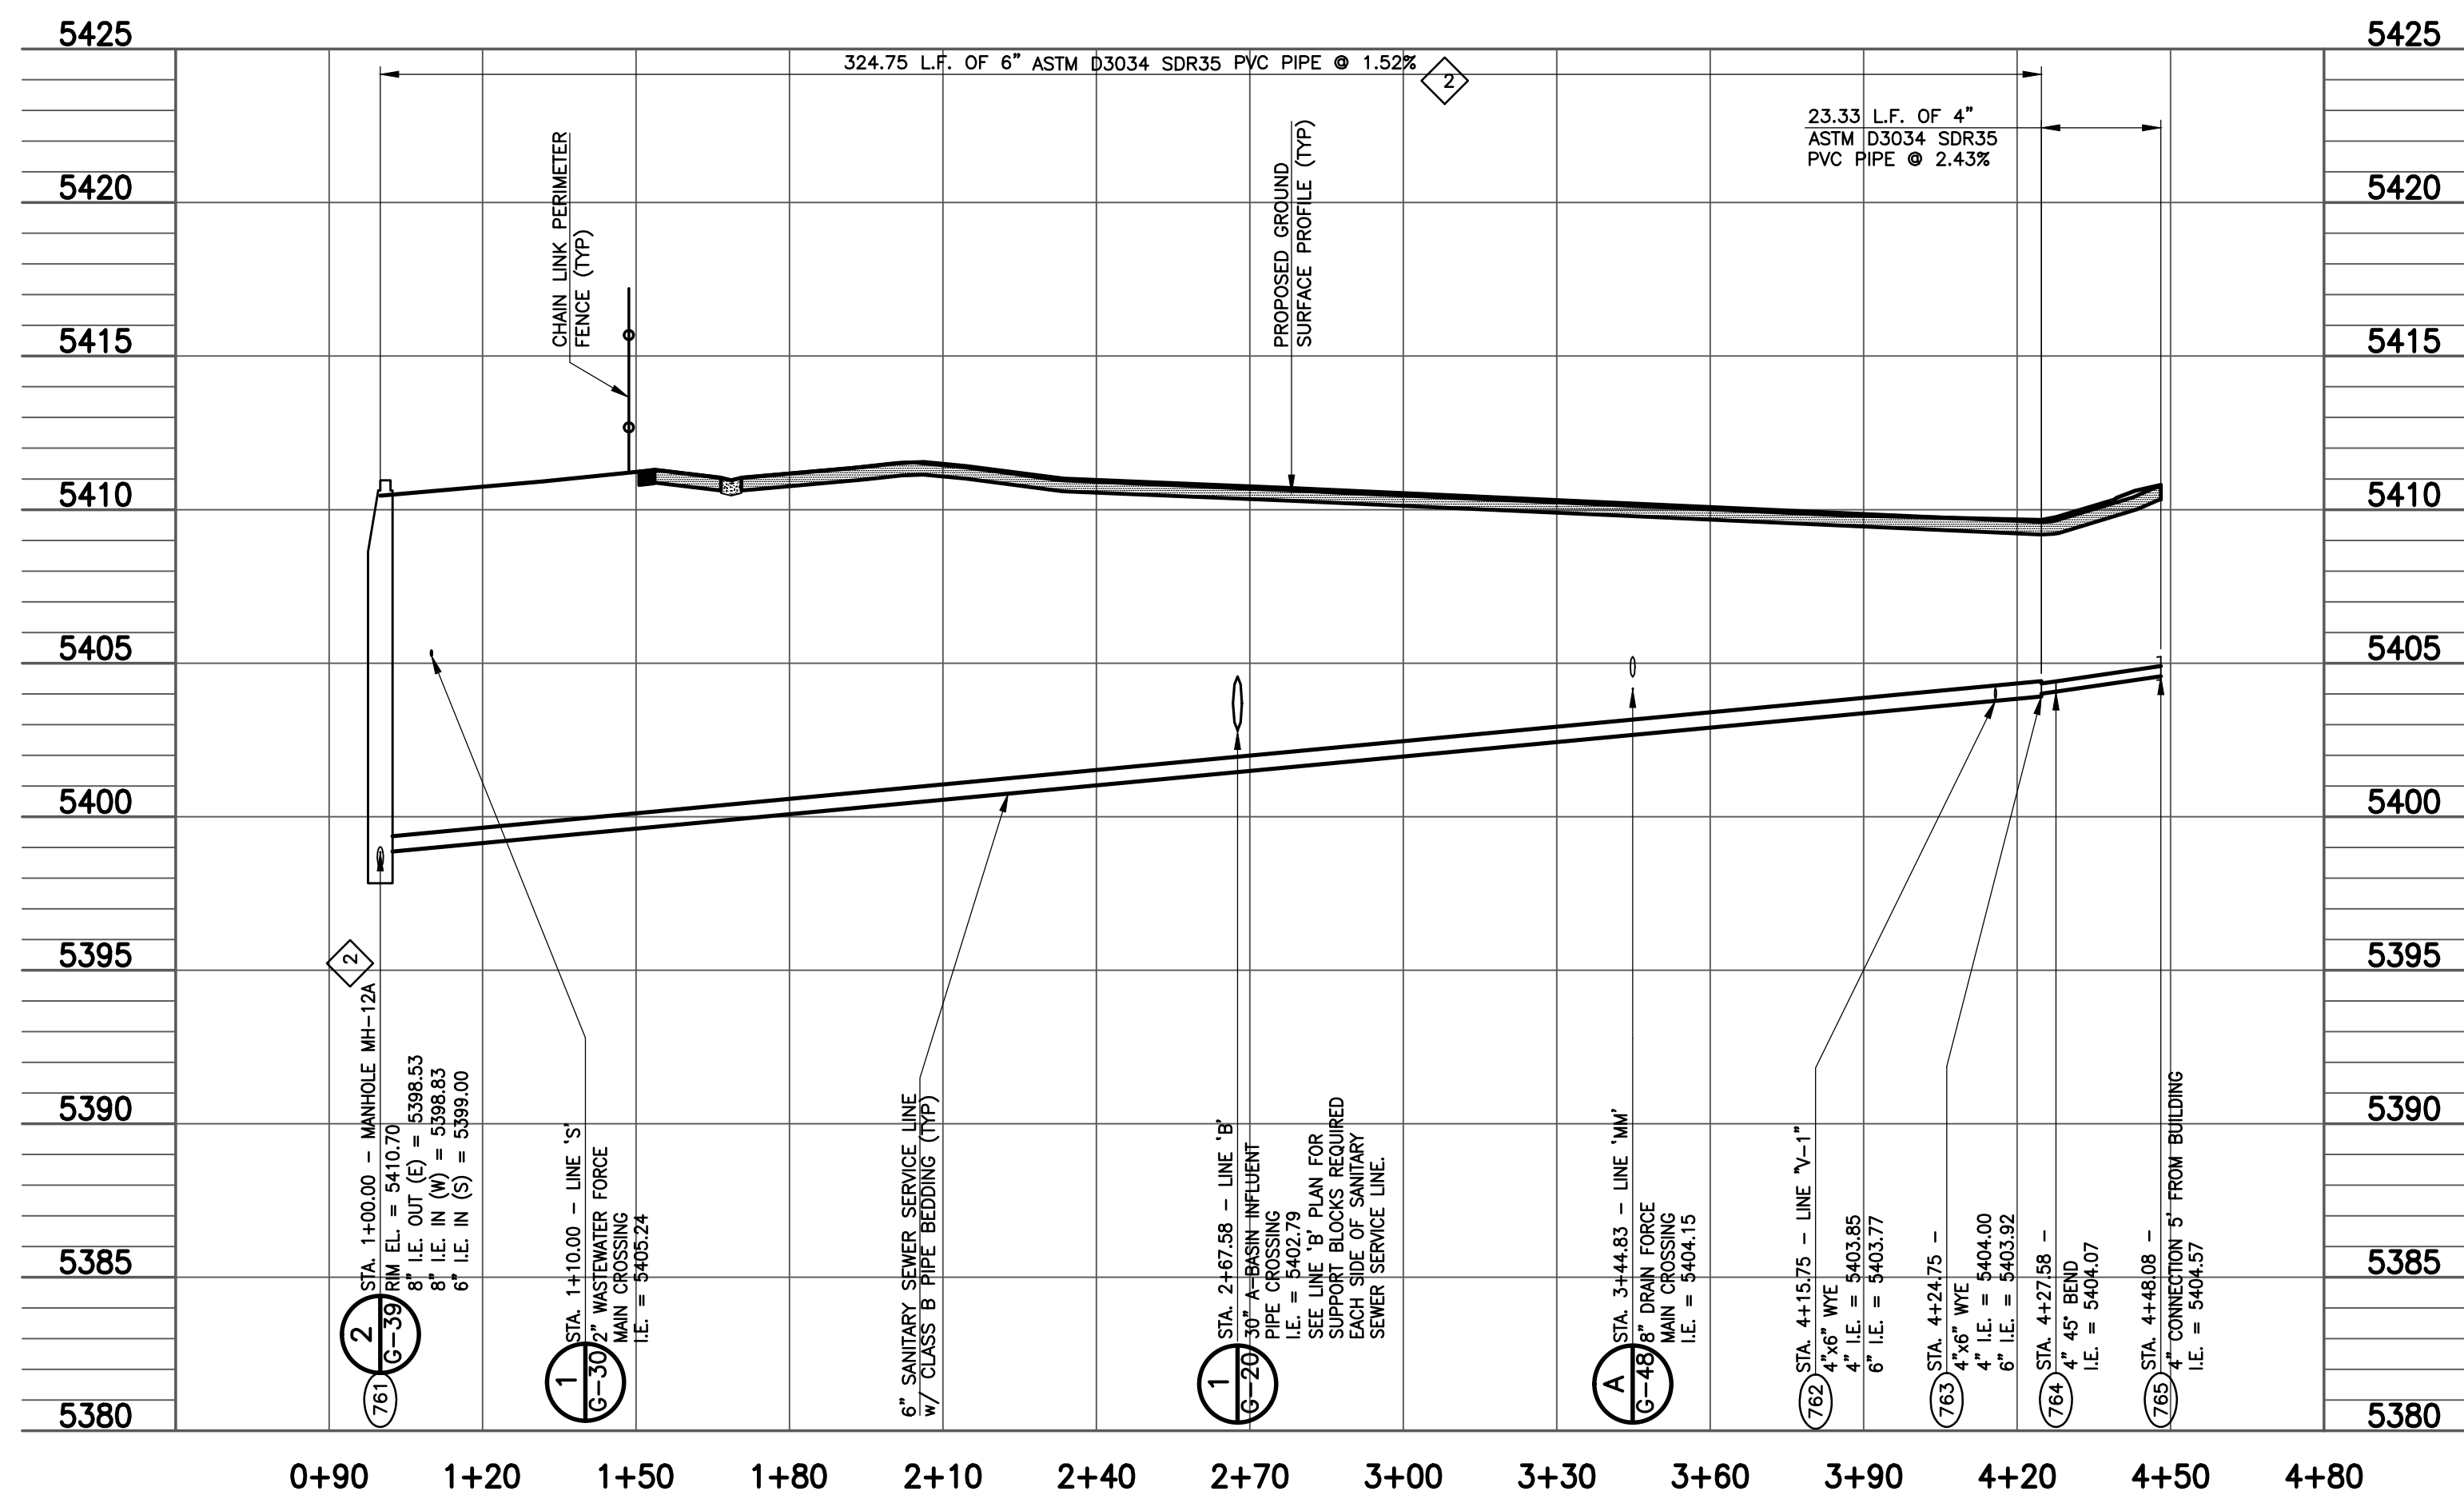


A LINE 'V' - EM BUILDING SANITARY SEWER SERVICE LINE PROFILE
 SCALE: HORIZ. 1" = 30' VERT. 1" = 5'

CONSTRUCTION NOTES:

- FURNISH AND INSTALL TRACER WIRE PER SPECIFICATION SECTION 02708 ON 6-INCH PIPELINES, STATION 1+00 TO STATION 4+24.75 AND ON 4-INCH BRANCH PIPING TO SAND AND OIL INTERCEPTOR AND EM BUILDING SEWER.
- RUN TRACER WIRE UP OUTSIDE OF MANHOLE AT STATION 1+00 AND UP OUTSIDE OF CLEANOUT AT APPROXIMATE STATION 4+29 LT. EXTEND TRACER WIRE UP OUTSIDE OF SAND AND OIL INTERCEPTOR AND AT FOUNDATION.

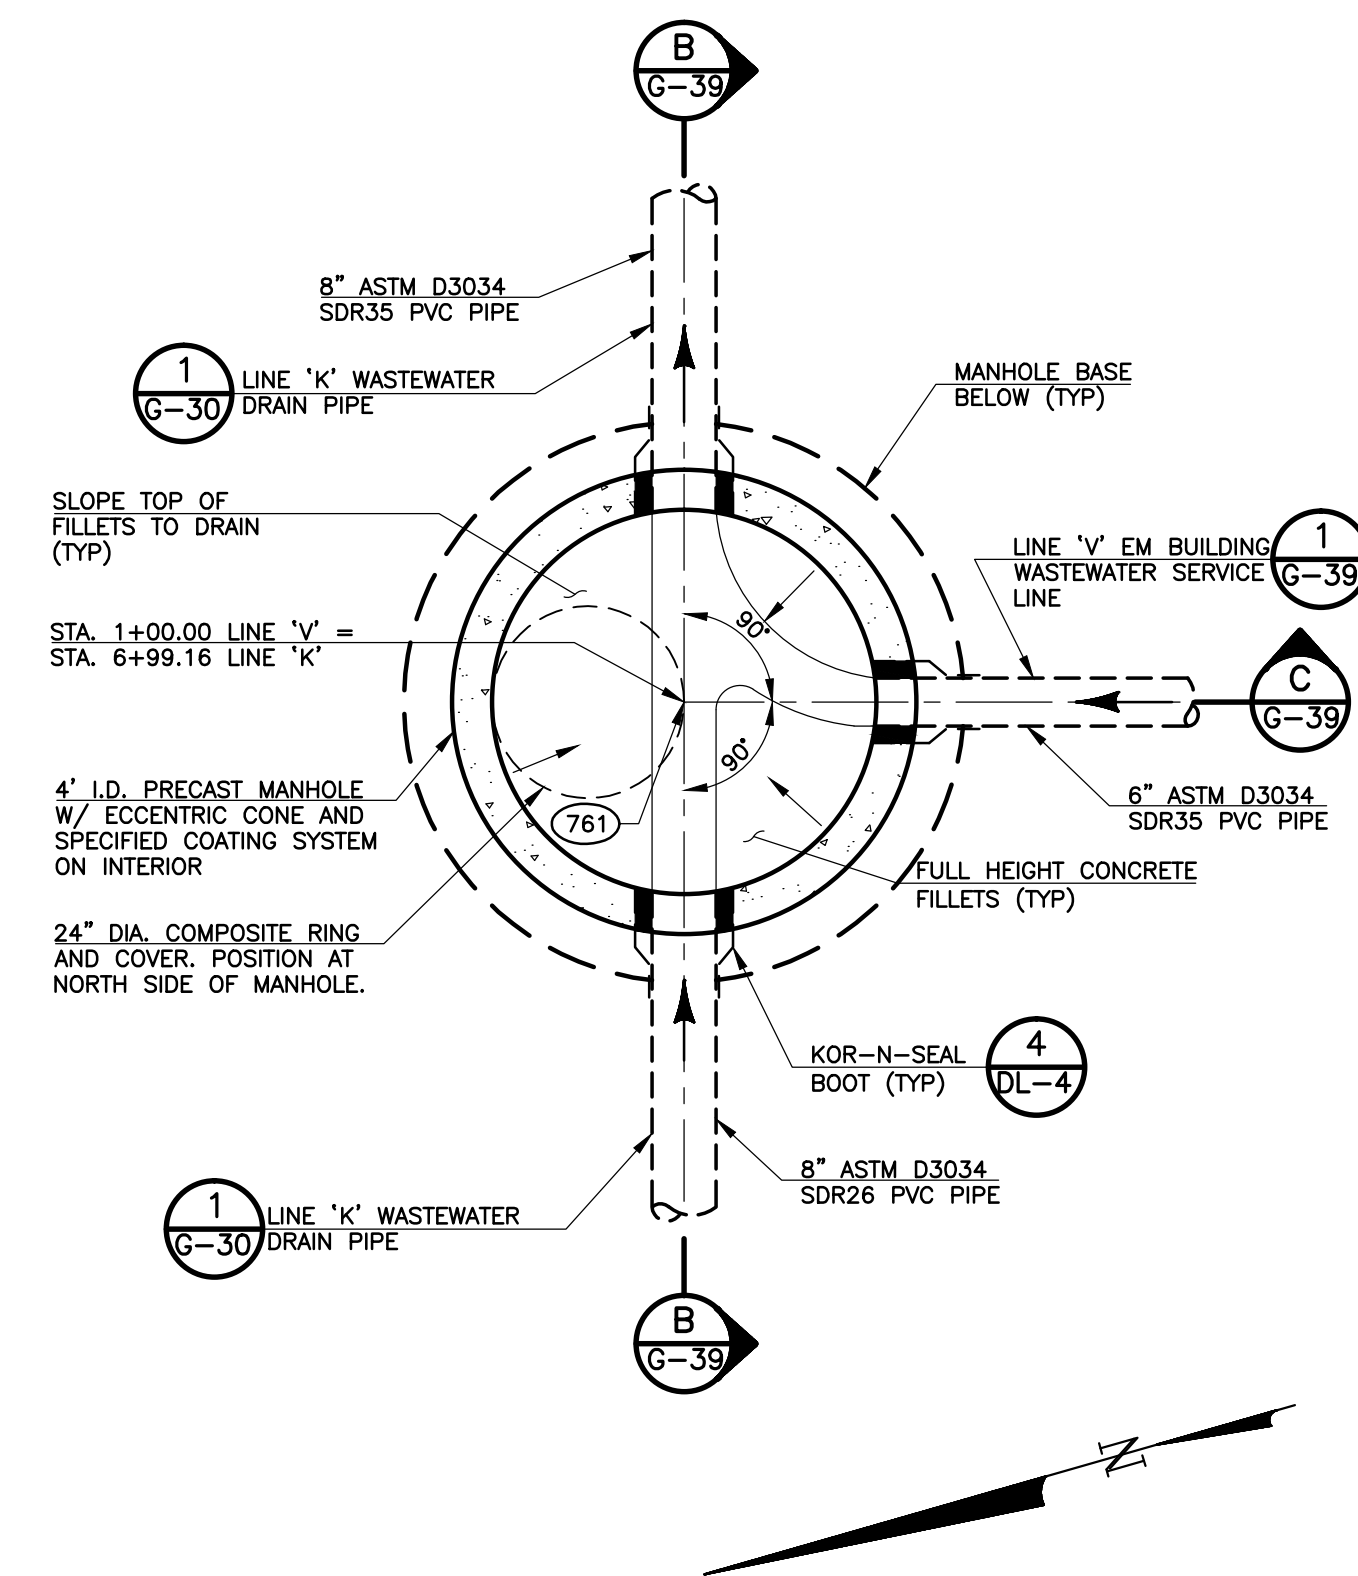

2 MANHOLE MH-12A PLAN
 SCALE: 1/2" = 1'-0"

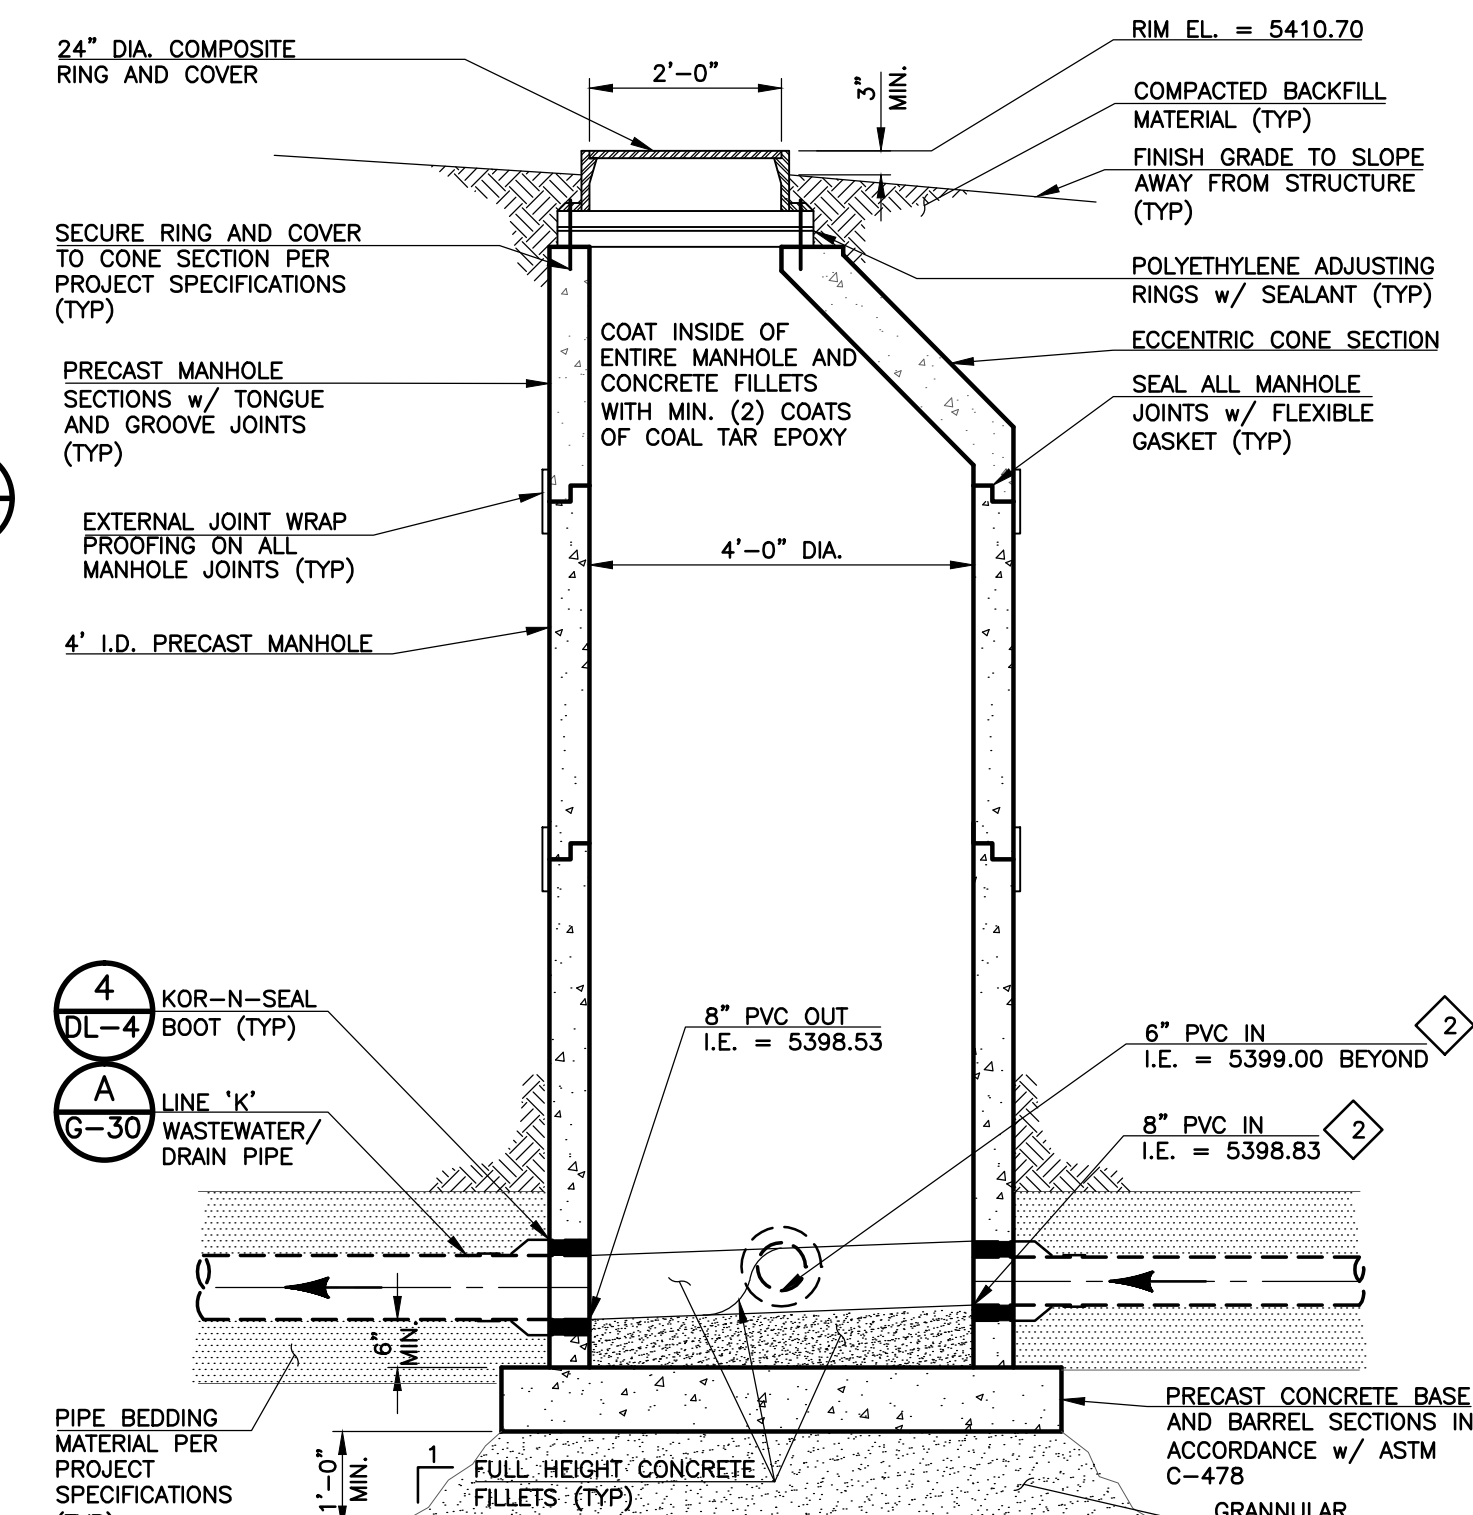

B MANHOLE MH-12A SECTION
 SCALE: 1/2" = 1'-0"

REVISIONS		
NO.	DATE	DESCRIPTION
1	03/09/2012	ISSUED FOR CONSTRUCTION
2	04/27/2012	SHOP SUBMITTAL NO. 02709-006 COMMENTS

THIS DRAWING IS THE PROPERTY OF GMS, INC., AND IS NOT TO BE RE-PRODUCED, MODIFIED OR USED FOR ANY OTHER PROJECT OR EXTENSION OF THIS PROJECT EXCEPT BY AGREEMENT WITH THIS COMPANY.

LINE 'V' - EM BUILDING SANITARY SEWER SERVICE LINE PLAN AND PROFILE AND DETAILS
 HAROLD D. THOMPSON REGIONAL WATER RECLAMATION FACILITY
 LOWER FOUNTAIN METROPOLITAN SEWAGE DISPOSAL DISTRICT

DRAWN: SKC
 DESIGNED: MAM
 CHECKED: RJS
 DATE: 2012
 PROJECT NO.: 20166.325
 GMS FILE NO.: 2599

GMS, INC.
 CONSULTING ENGINEERS
 611 N. WEBER, SUITE 300
 COLORADO SPRINGS, COLORADO 80903

SHEET
G-39
 OF
 -