



Q:\PLANS\2010\0620\0620G02G02.dwg, CDE, 8/10/2012 10:19:17 AM, SC, DWG, TYP, PLOT, 1:1

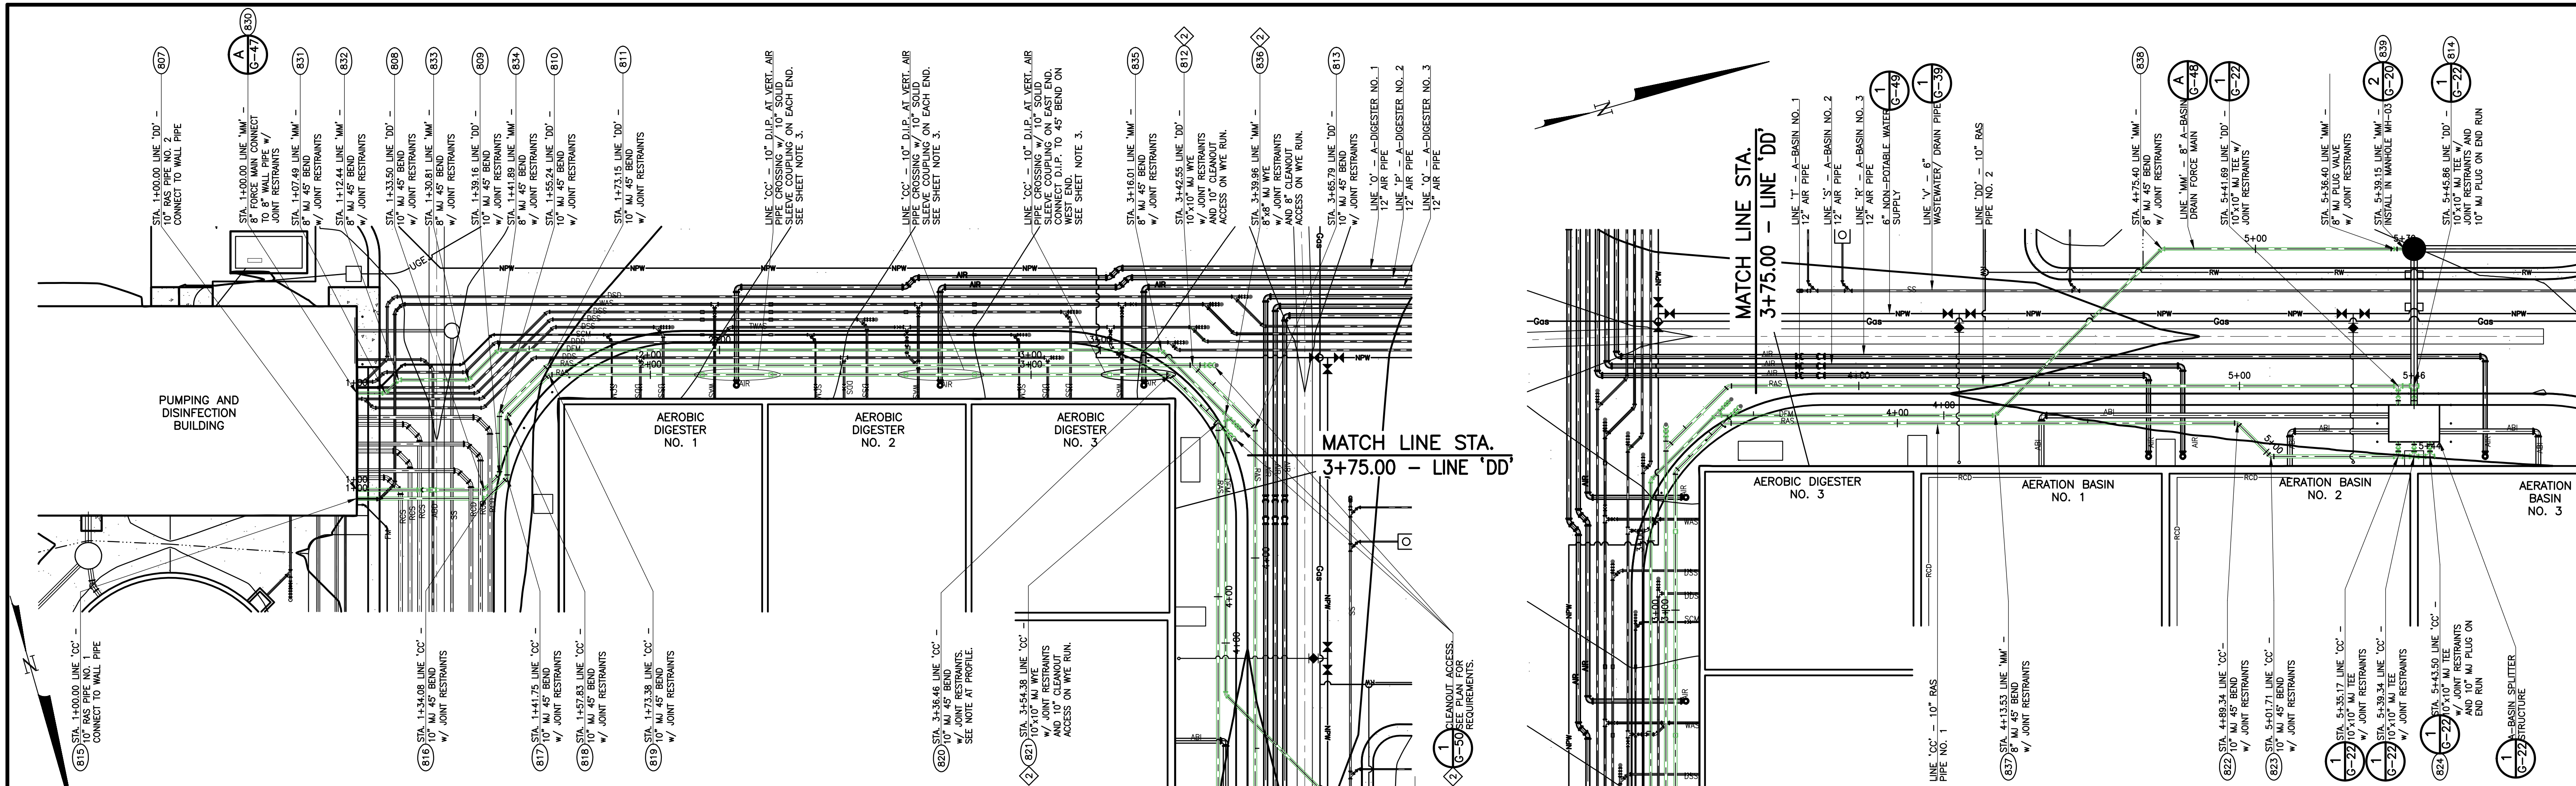

1
G-42
LINES 'CC' AND 'DD' - RAS PIPE NOS. 1 AND 2 PLAN
LINE 'MM' - 8" DRAIN FORCE MAIN PLAN
SCALE: 1" = 20'

2
G-42
LINES 'CC' AND 'DD' - RAS PIPE NOS. 1 AND 2 PLAN
LINE 'MM' - 8" DRAIN FORCE MAIN PLAN
SCALE: 1" = 20'

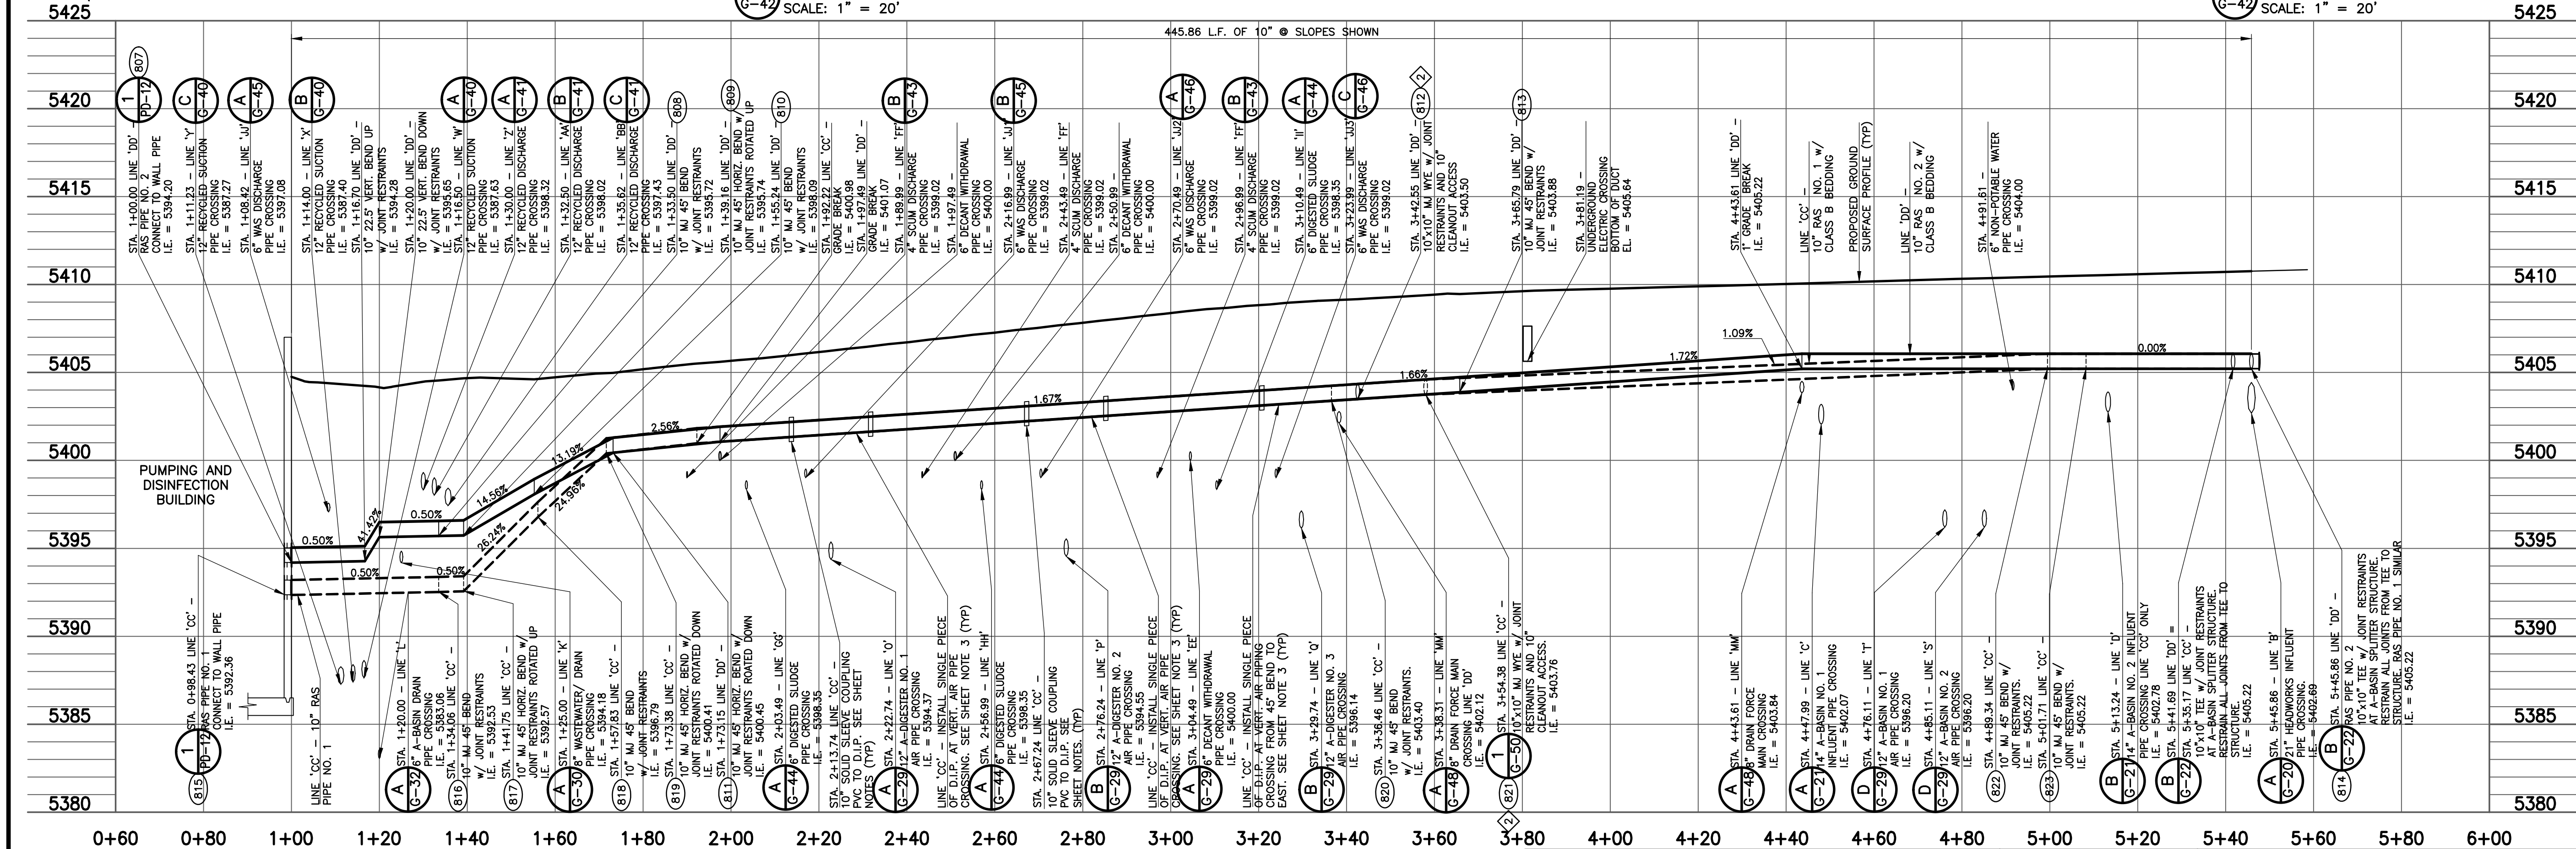

A
G-42
LINE 'CC' - RAS PIPE NO. 1 PROFILE
LINE 'DD' - RAS PIPE NO. 2 PROFILE
SCALE: 1" = 20'

REVISIONS		
NO.	DATE	DESCRIPTION
1	07/18/2012	ISSUED FOR CONSTRUCTION
2	07/31/2012	REVISED CLEANOUT ACCESS POINTS

THIS DRAWING IS THE PROPERTY OF GMS, INC., AND IS NOT TO BE REPRODUCED, MODIFIED OR USED FOR ANY OTHER PROJECT OR EXTENSION OF THIS PROJECT EXCEPT BY AGREEMENT WITH THIS COMPANY.

LINES 'CC' AND 'DD' - RAS PIPE NOS. 1 AND 2 PLAN AND PROFILE
LINE 'MM' - 8" DRAIN FORCE MAIN PLAN
HAROLD D. THOMPSON REGIONAL WATER RECLAMATION FACILITY
LOWER FOUNTAIN METROPOLITAN SEWER DISPOSAL DISTRICT

DRAWN: SKC
DESIGNED: MAM
CHECKED: RJS
DATE: 2012
PROJECT NO.: 20166.325
GMS FILE NO.: 2599

GMS, INC.
CONSULTING ENGINEERS
611 N. WEBER, SUITE 300
COLORADO SPRINGS, COLORADO 80903

SHEET
G-42
OF
1

XREF FILENAME: G:\PLOT STYLE FILE: LPMISO.DWG: G-41.dwg
FILENAME: G:\PLOT STYLE FILE: LPMISO.DWG: G-41.dwg