



G:\PROJECTS\2010\0620\G47.dwg, G47, 9/21/2012 5:31:11 PM, & DWG TO PLOT job, 1.1

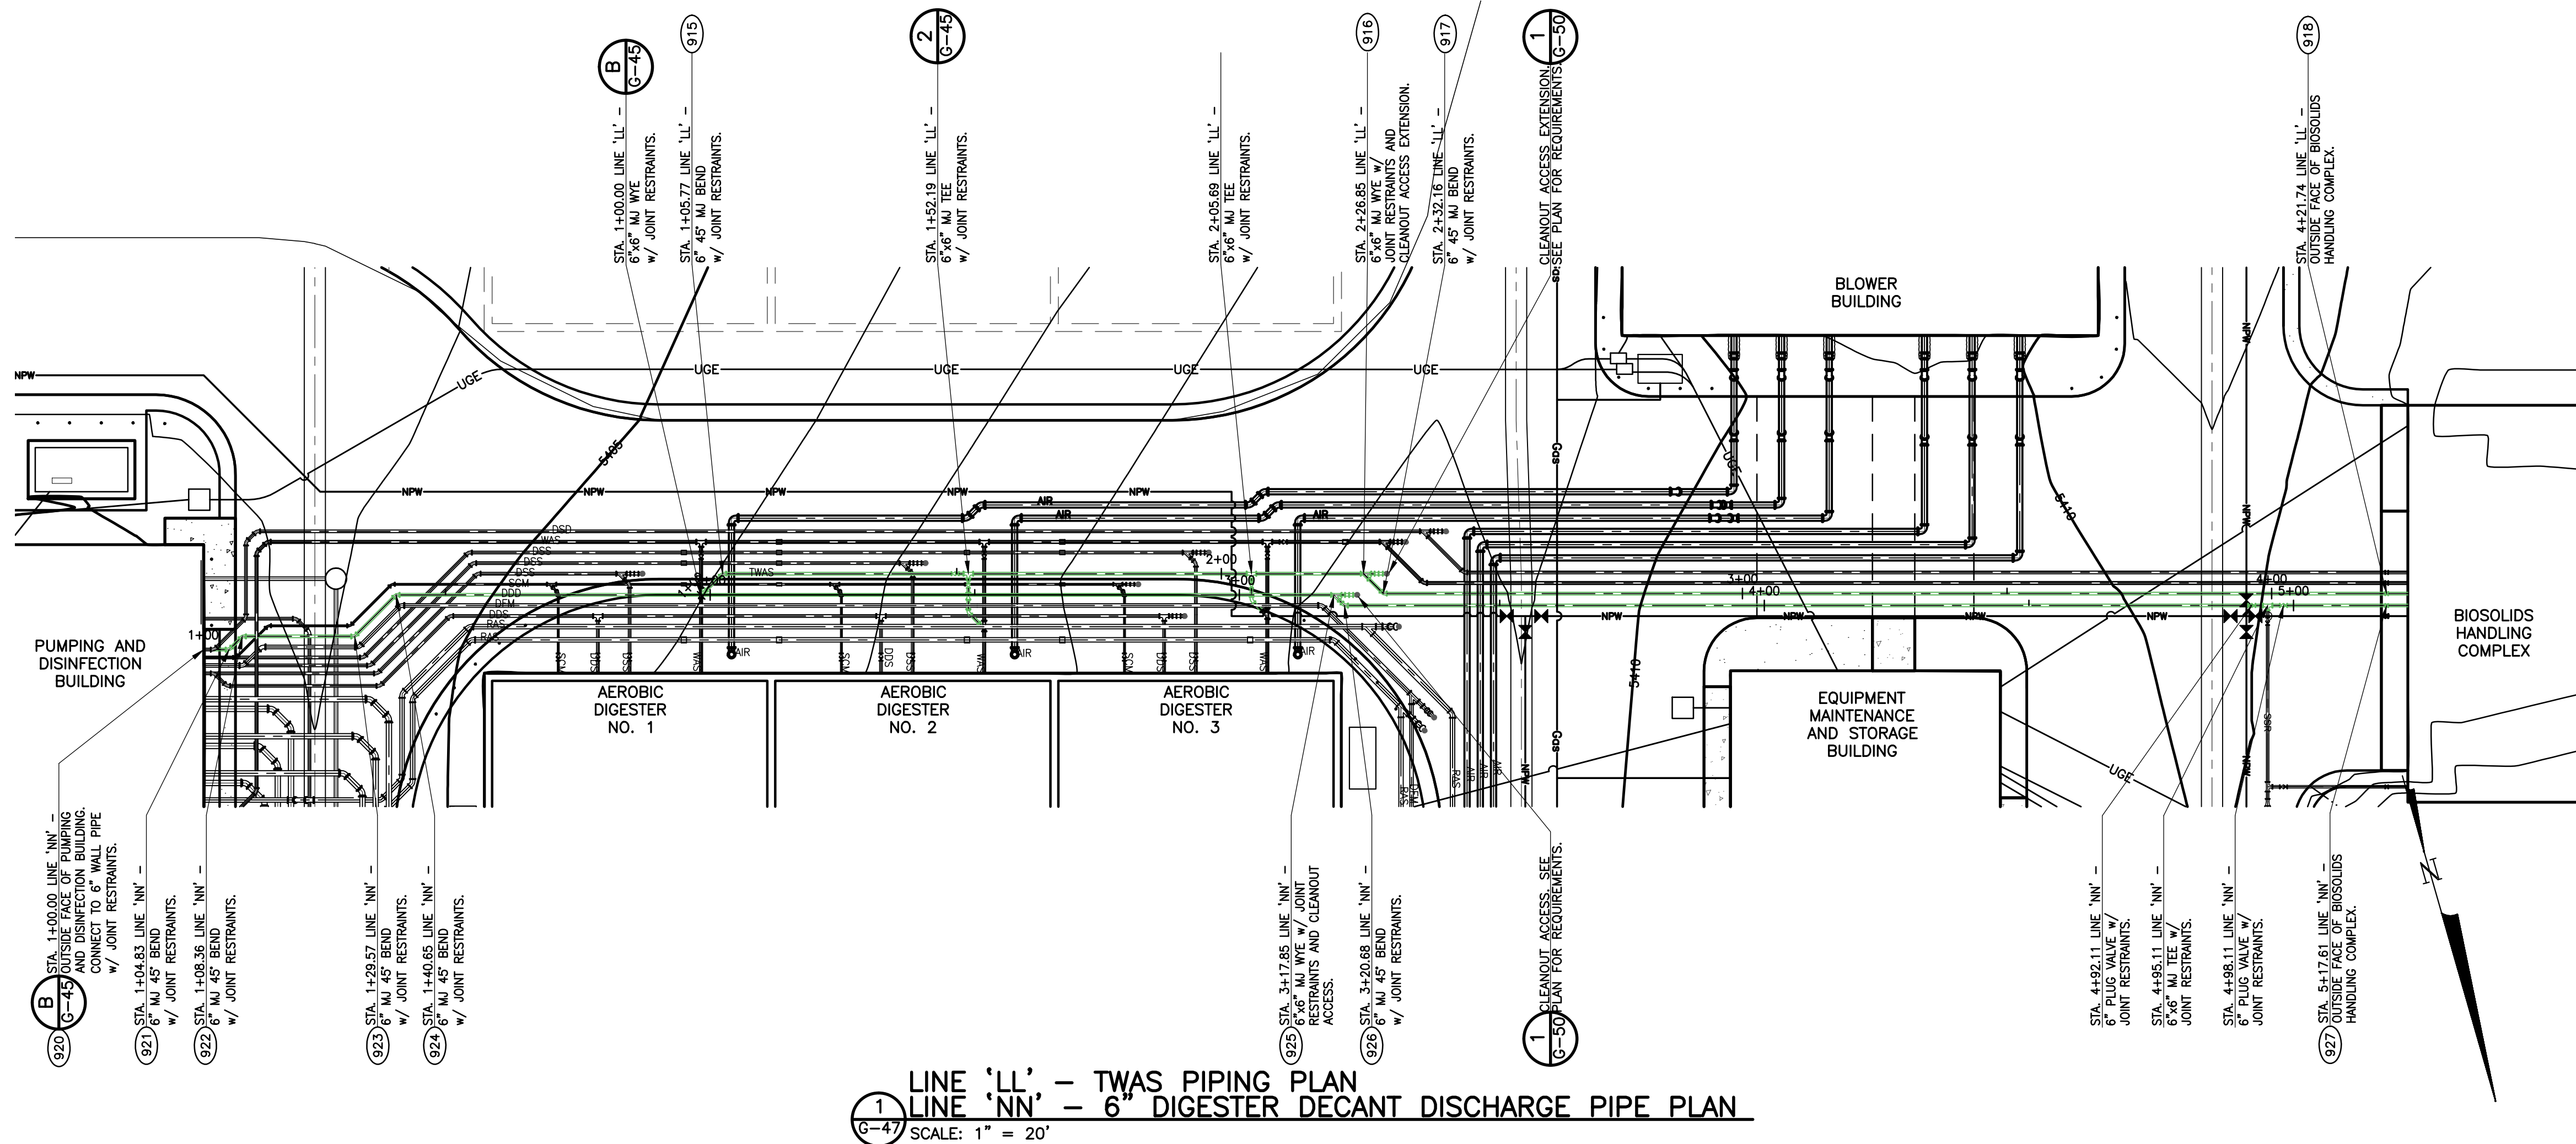

1
6-47 LINE 'LL' - TWAS PIPING PLAN
LINE 'NN' - 6" DIGESTER DECANT DISCHARGE PIPE PLAN
SCALE: 1" = 20'

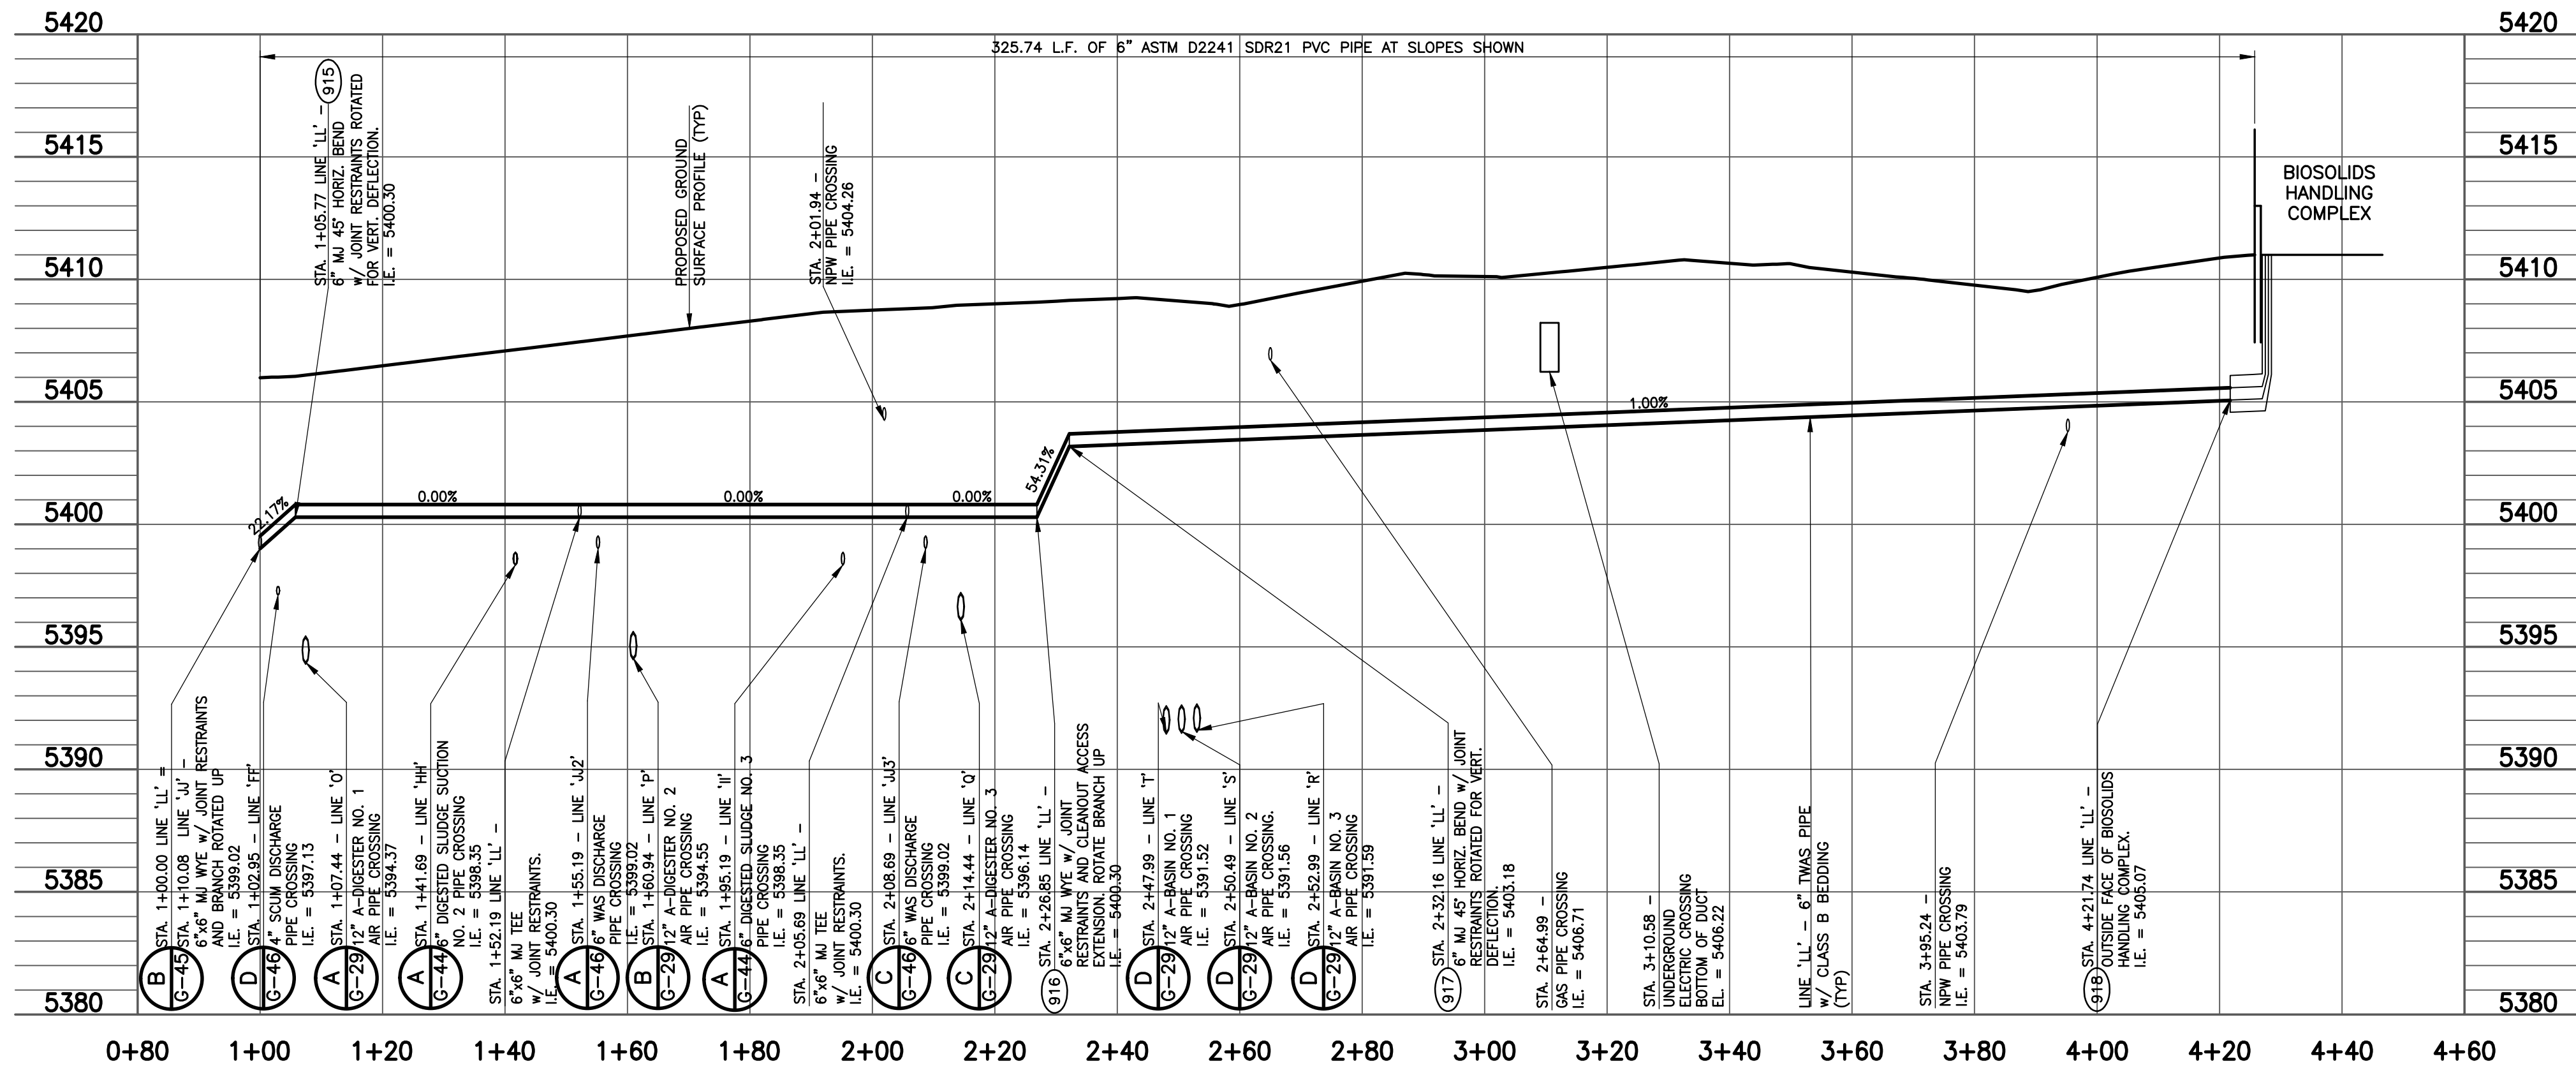

1
6-47 LINE 'LL' - TWAS PIPING PROFILE
SCALE: 1" = 20'

SHEET NOTES:

1. VALVE OPERATOR EXTENSIONS REQUIRED ON ALL VALVE OPERATING NUTS MORE THAN 4- FEET BELOW FINISHED SURFACE.
2. FOR ALL 6" FITTINGS WITH JOINT RESTRAINTS ON THICKENED WAS PIPING, RESTRAIN ALL JOINTS ON EACH SIDE OF BEND OR FITTING A MINIMUM LENGTH OF 5 FEET, EXCEPT FOR BRANCH SIDES OF TEES THAT REQUIRE A MINIMUM 8 FEET OF RESTRAINED PIPE.

REVISIONS		
NO.	DATE	DESCRIPTION
1	09/20/2012	ISSUED FOR CONSTRUCTION

THIS DRAWING IS THE PROPERTY OF GMS, INC., AND IS NOT TO BE RE-PRODUCED, MODIFIED OR USED FOR ANY OTHER PROJECT OR EXTENSION OF THIS PROJECT EXCEPT BY AGREEMENT WITH THIS COMPANY.

LINE 'LL' - TWAS PIPING PLAN AND PROFILE
LINE 'NN' - 6" DIGESTER DECANT DISCHARGE PIPE PLAN
HAROLD D. THOMPSON REGIONAL WATER RECLAMATION FACILITY
LOWER FOUNTAIN METROPOLITAN SEWAGE DISPOSAL DISTRICT

DRAWN SKC
DESIGNED MAM
CHECKED RJS
DATE 2012
PROJECT NO. 20166.325
GMS FILE NO. 2599

GMS, INC.

CONSULTING ENGINEERS
611 N. WEBER, SUITE 300
COLORADO SPRINGS, COLORADO 80903

SHEET
G-47
OF
1

XREF FILENAME: G:\
BASE DWG: G\1
PLOT STYLE FILE: LFMSSD GREEN, G-41.dwg
FILENAME: G:\LFMSSD\20166\325\G47.dwg

© 2012 GMS, INC.