



1 PUMPING AND DISINFECTION BUILDING - EAST ELEVATION
SCALE: 1" = 5'-0"

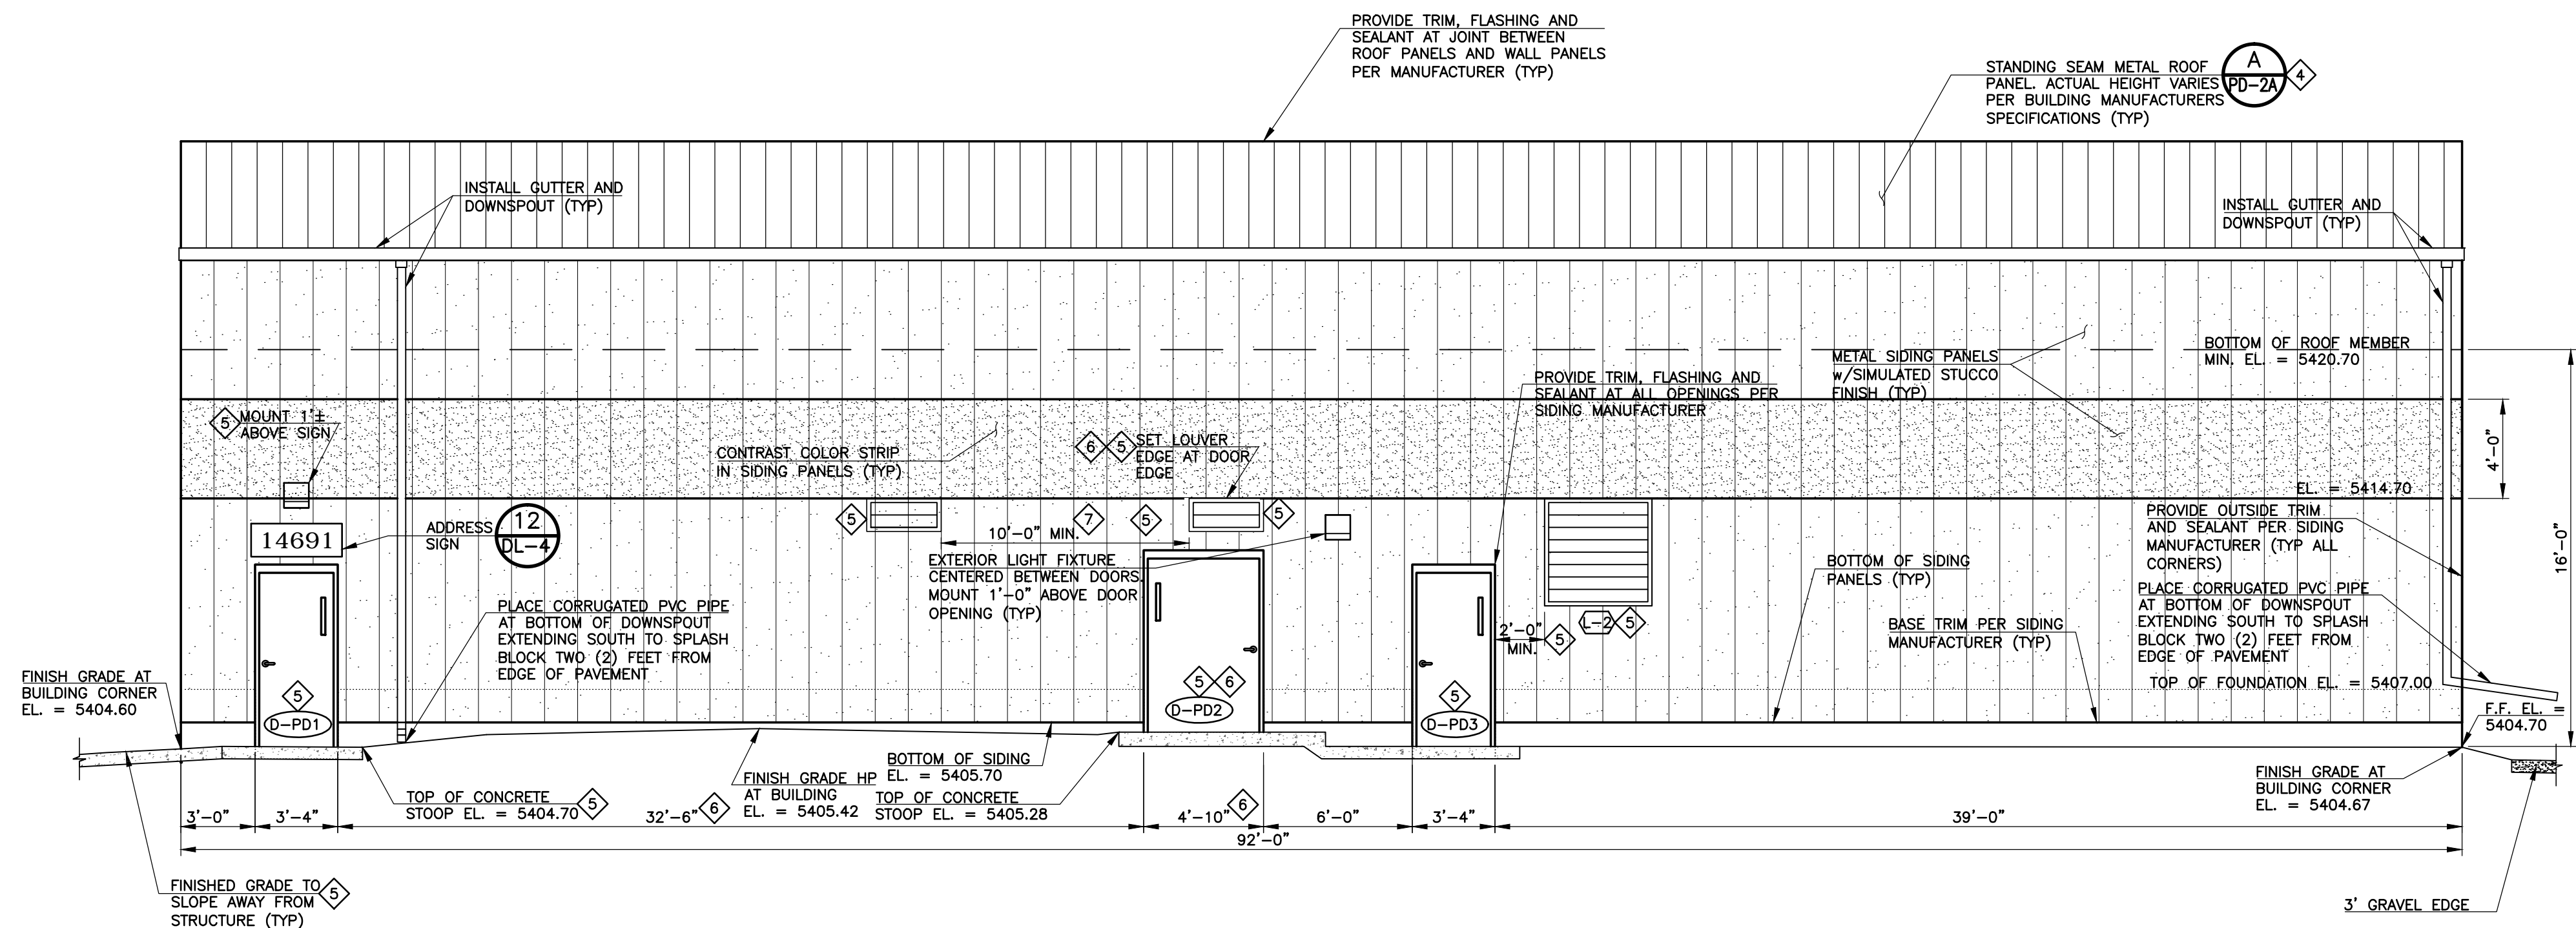


2 PUMPING AND DISINFECTION BUILDING - SOUTH ELEVATION
SCALE: 1" = 5'-0"

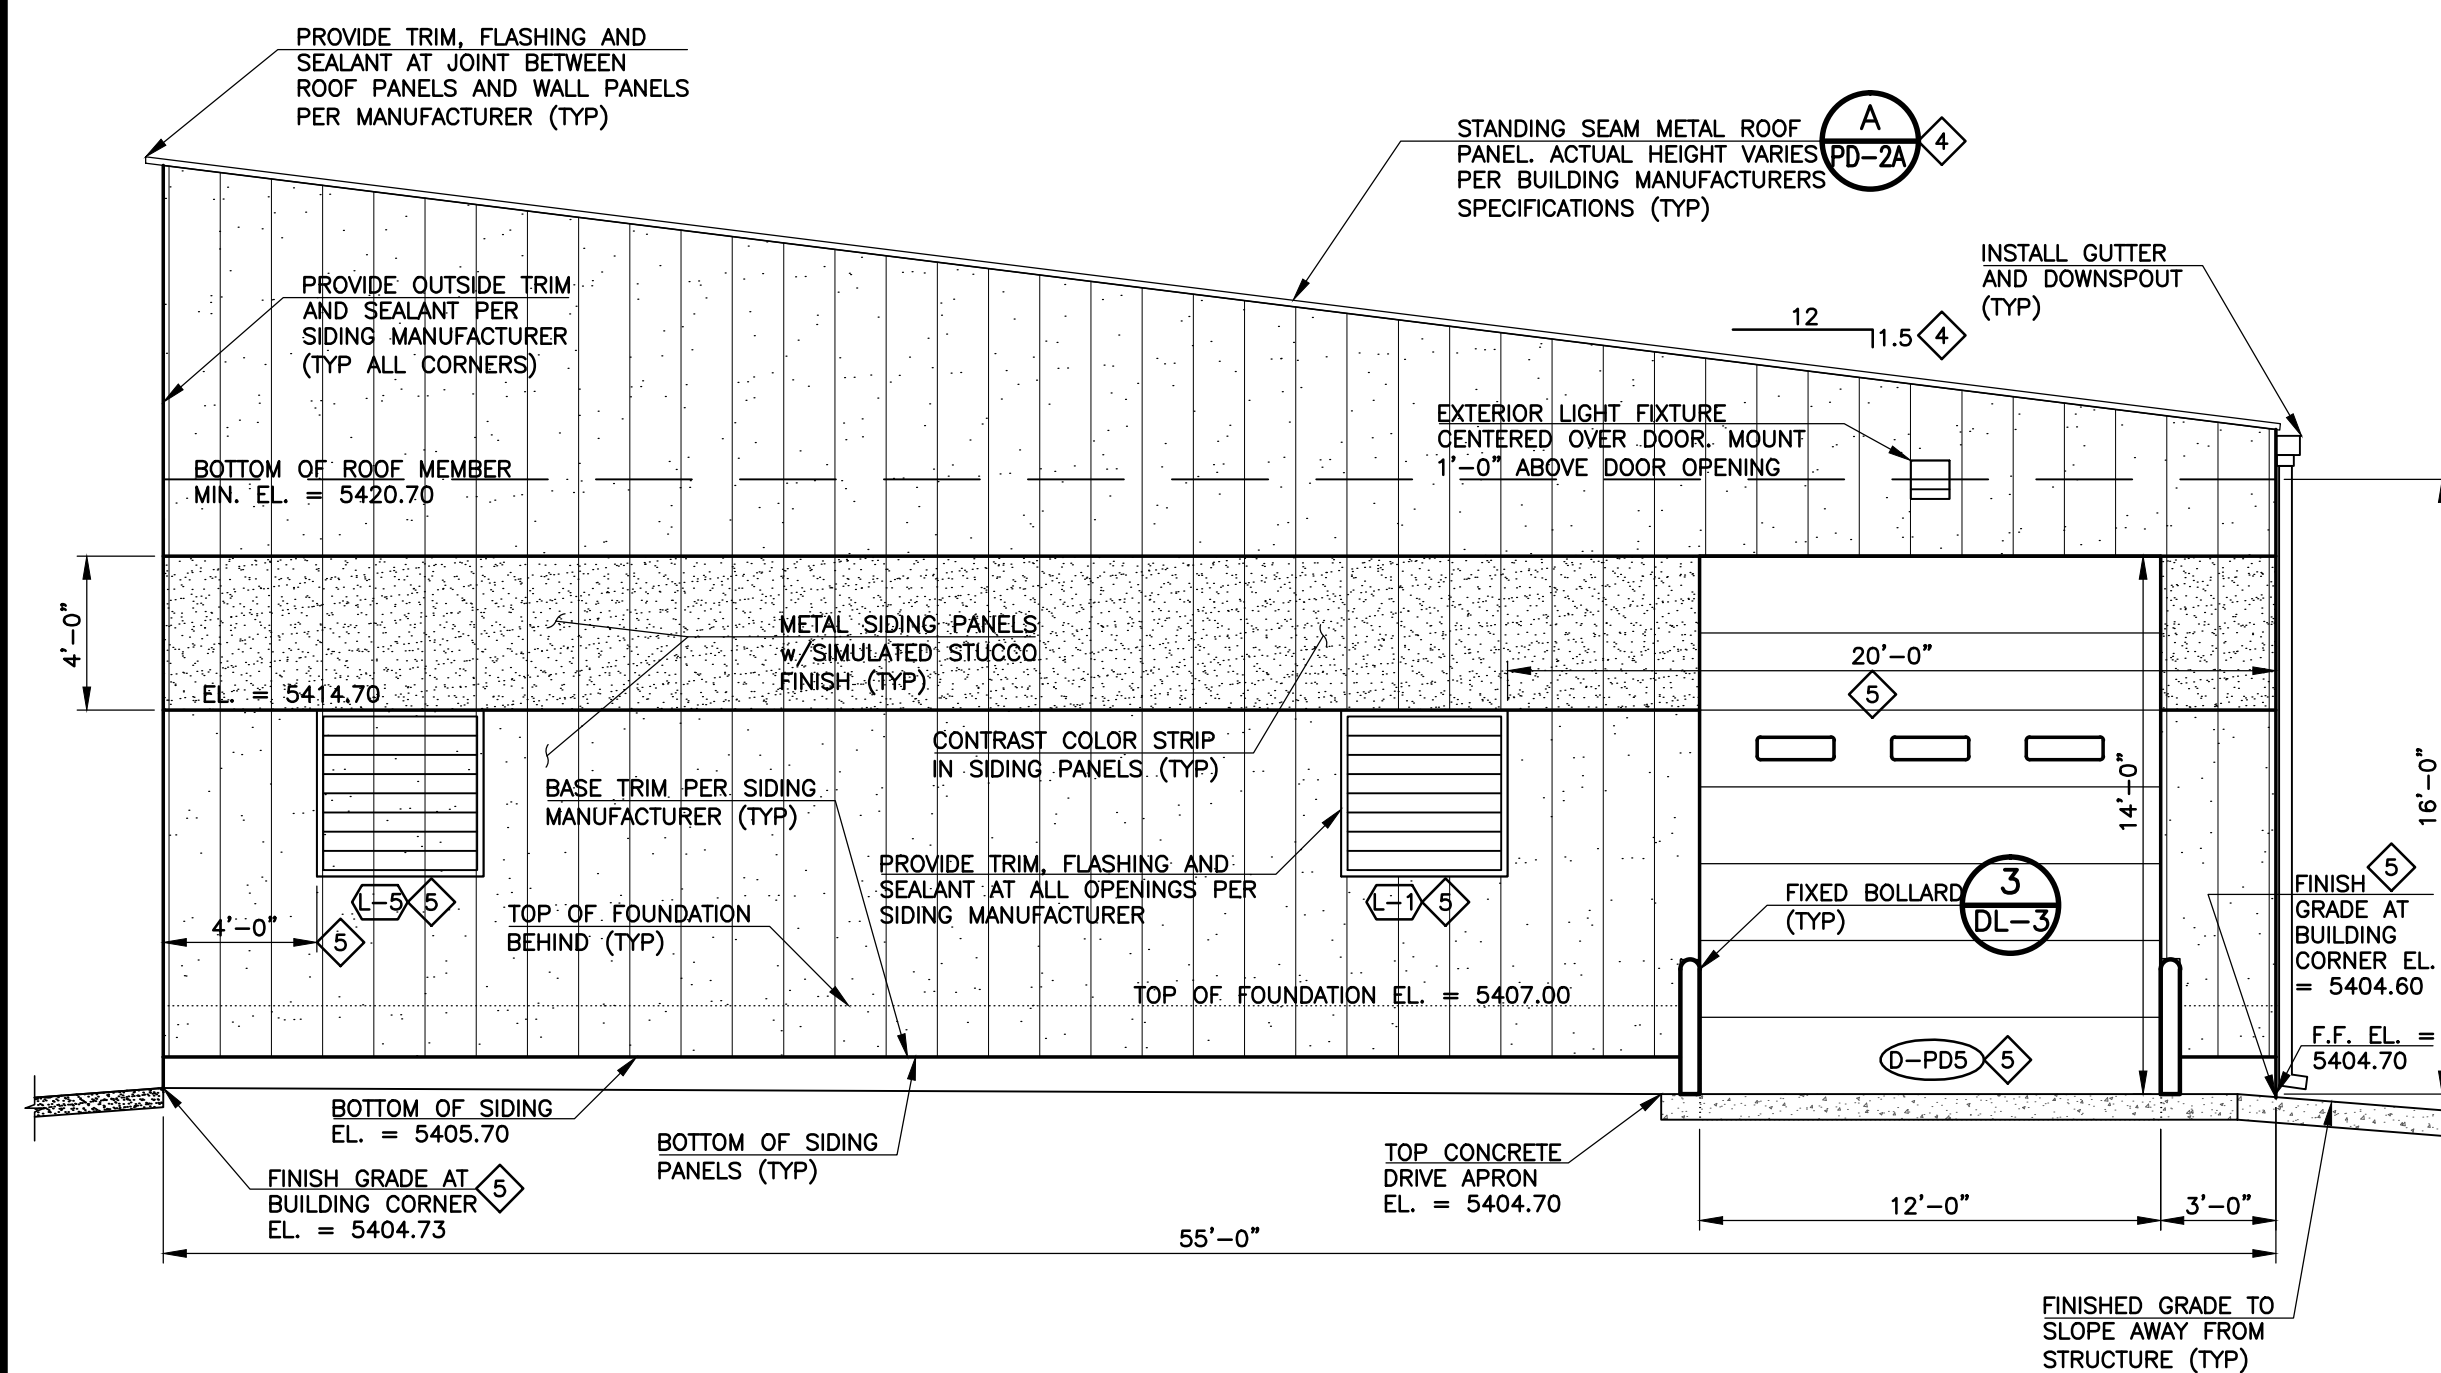

3 PUMPING AND DISINFECTION BUILDING - WEST ELEVATION
SCALE: 1" = 5'-0"

SHEET NOTES:

- REFER TO MECHANICAL DRAWINGS FOR PENETRATION REQUIREMENTS ON DUCTWORK, LOUVERS, ETC. VERIFY WALL PENETRATION SIZES WITH MECHANICAL EQUIPMENT REQUIREMENTS. PROVIDE TRIM, FLASHING AND SEALANT AROUND ALL PENETRATIONS PER SIDING MANUFACTURER.
- REFER TO ARCHITECTURAL DETAILS FOR DOOR LITE REQUIREMENTS.
- SET ALL LOUVER ELEVATIONS SO TOP OF LOUVER IS AT THE BOTTOM OF THE SIDING CONTRAST COLOR STRIP. COORDINATE WITH THE BUILDING SUPPLIER FOR OPENING REQUIREMENTS.

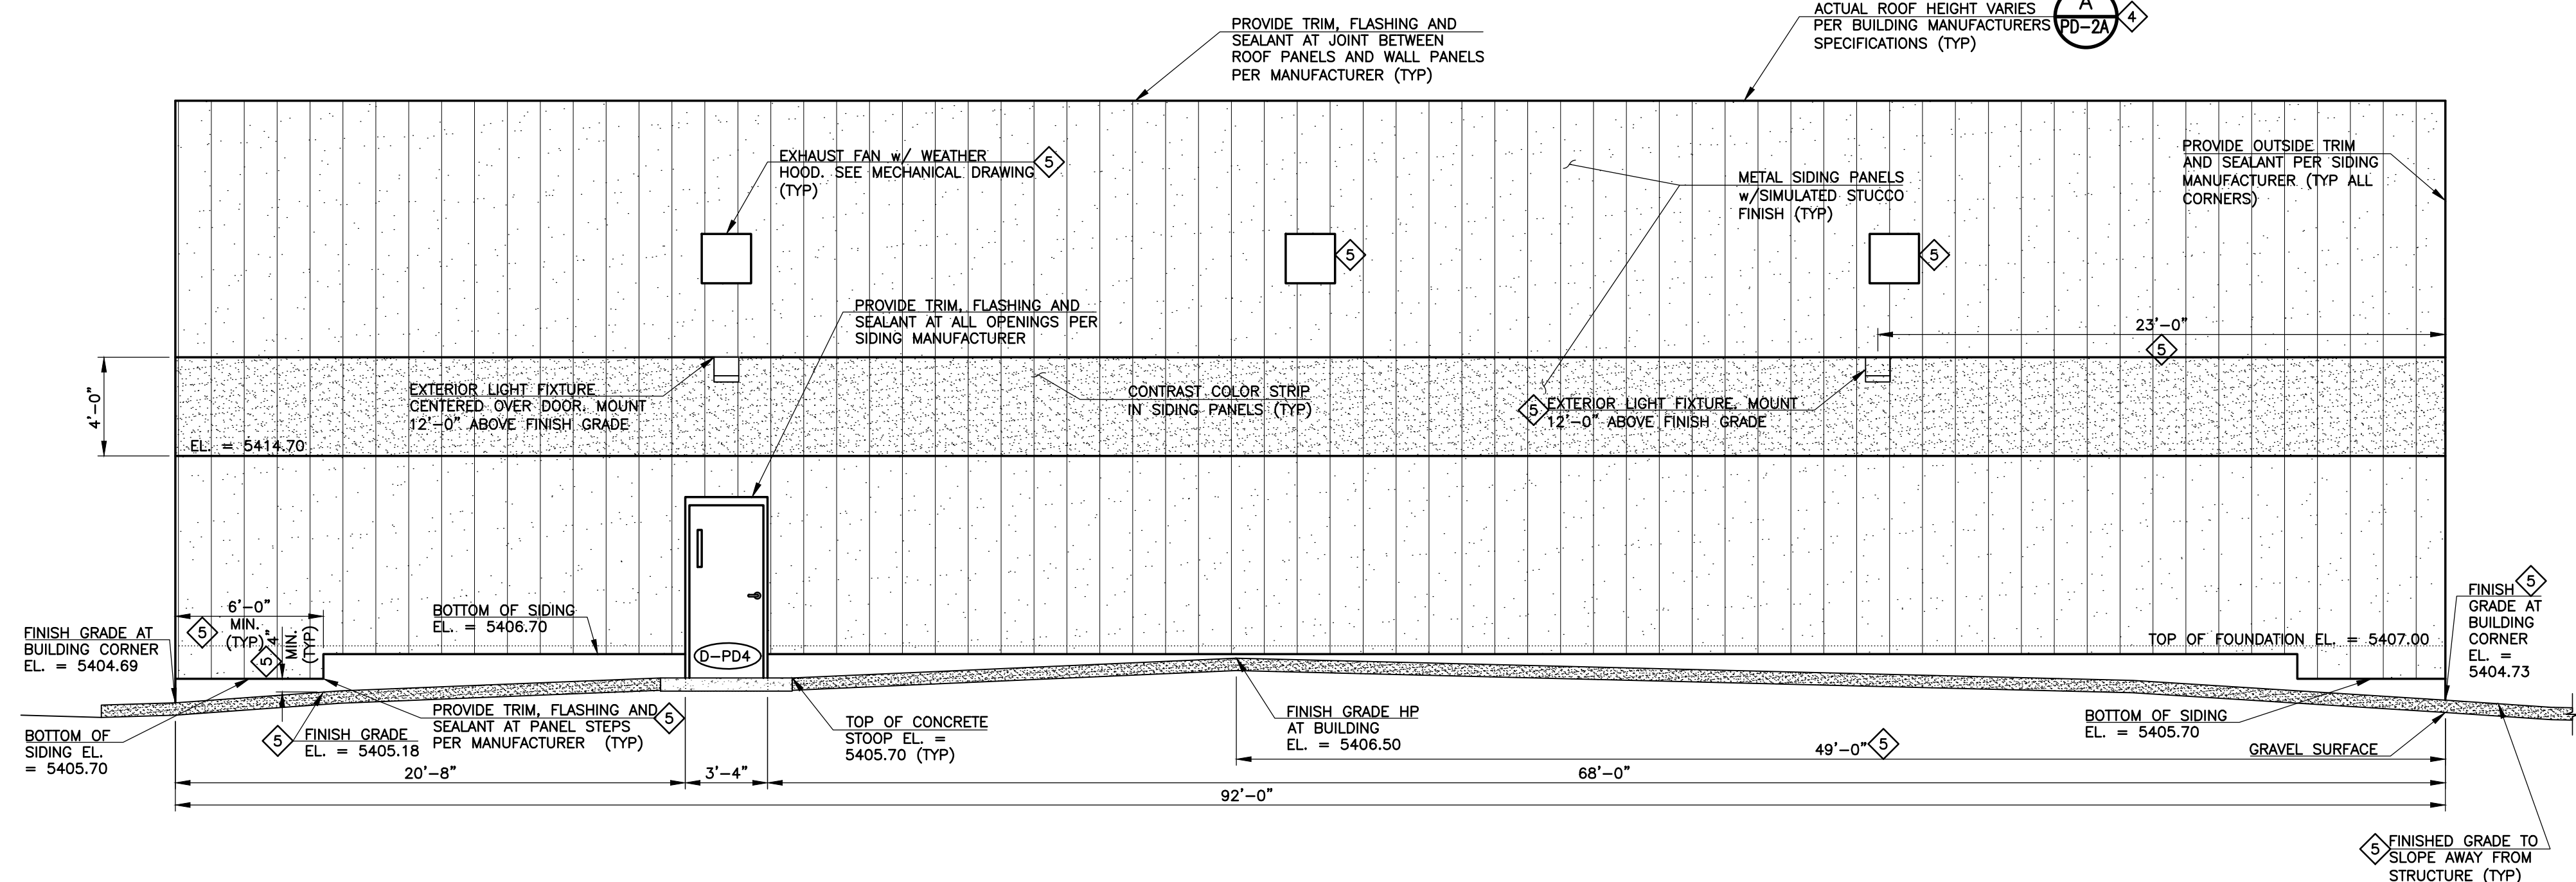

4 PUMPING AND DISINFECTION BUILDING - NORTH ELEVATION
SCALE: 1" = 5'-0"

| REVISIONS | | |
|-----------|------------|---|
| NO. | DATE | DESCRIPTION |
| 1 | 09/16/2011 | ISSUED FOR CMO PREPARATION (PUMPING AND DISINFECTION BUILDING FOUNDATION) |
| 2 | 09/16/2011 | ISSUED FOR FOUNDATION PERMIT SUBMITTAL TO PPRBD (PUMPING AND DISINFECTION BLDG) |
| 3 | 10/17/2011 | ISSUED FOR CONSTRUCTION PER PPRBD FOUNDATION PERMIT #88993 (PUMP AND DISINFECTION BLDG) |
| 4 | 01/08/2012 | ISSUED FOR VALUE ENGINEERING |
| 5 | 01/29/2012 | ISSUED FOR PD BUILDING VALUE ENGINEERING REVIEW AND COMMENTS |
| 6 | 04/18/2012 | ISSUED FOR BUILDING PERMIT SUBMITTAL TO PPRBD (PUMPING AND DISINFECTION BLDG) |
| 7 | 05/21/2012 | ISSUED FOR CONSTRUCTION PER PPRBD BLDG PERMIT #88993 (PUMP AND DISINFECTION BLDG) |

THIS DRAWING IS THE PROPERTY OF GMS, INC., AND IS NOT TO BE RE-PRODUCED, MODIFIED OR USED FOR ANY OTHER PROJECT OR EXTENSION OF THIS PROJECT EXCEPT BY AGREEMENT WITH THIS COMPANY.

| | | | |
|---|--|---|---------------------------------|
| ARCHITECTURAL ELEVATIONS HAROLD D. THOMPSON REGIONAL WATER RECLAMATION FACILITY LOWER FOUNTAIN METROPOLITAN SEWAGE DISPOSAL DISTRICT | | GMS, INC. CONSULTING ENGINEERS 611 N. WEBER, SUITE 300 COLORADO SPRINGS, COLORADO 80903 | SHEET PD-1 OF - |
| DRAWN: SKC DESIGNED: MAM CHECKED: RJS DATE: JANUARY 2012 PROJECT NO.: 20166.372 GMS FILE NO.: 2599 | | | |

XREF FILENAME: G:\PLOT STYLE FILE: 100SC.DWG
FILENAME: G:\PMSDD\20166\372\PD1\PD1.DWG