



A WEST WALL PROCESS PIPING SECTION
 PD-15 SCALE: 3/8" = 1'-0"

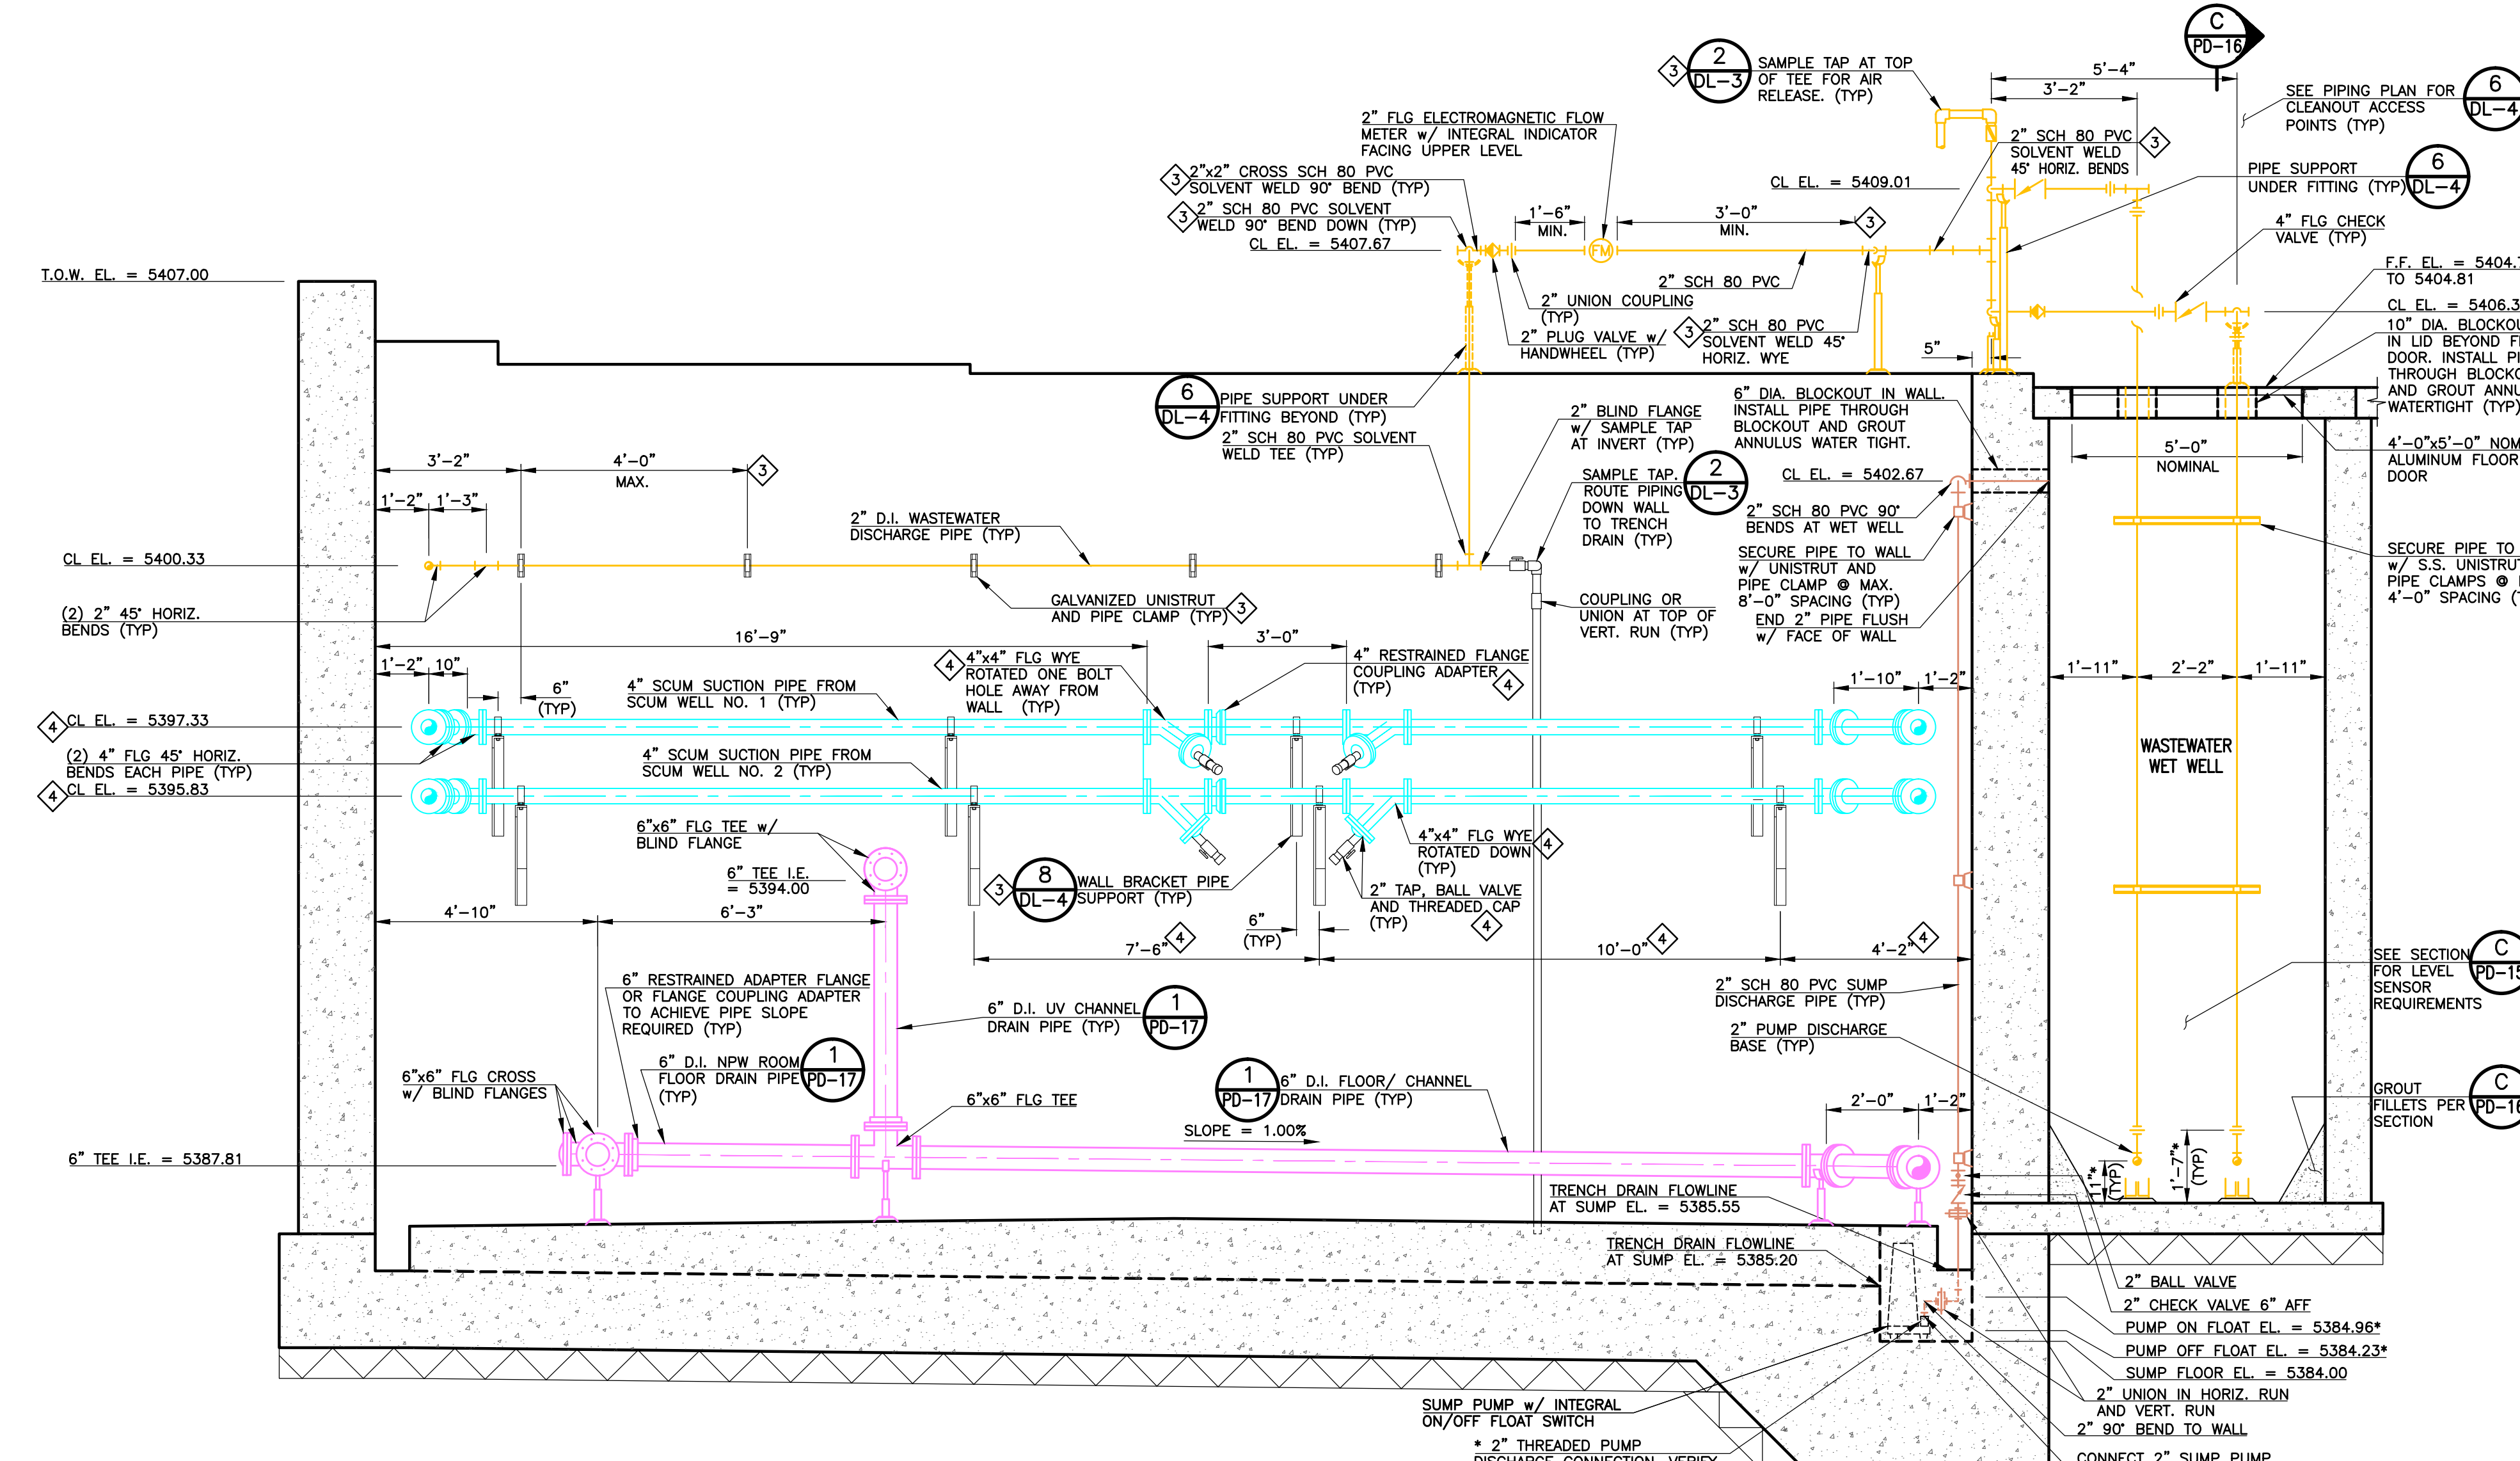

B EAST WALL PROCESS PIPING SECTION
 PD-16 SCALE: 3/8" = 1'-0"

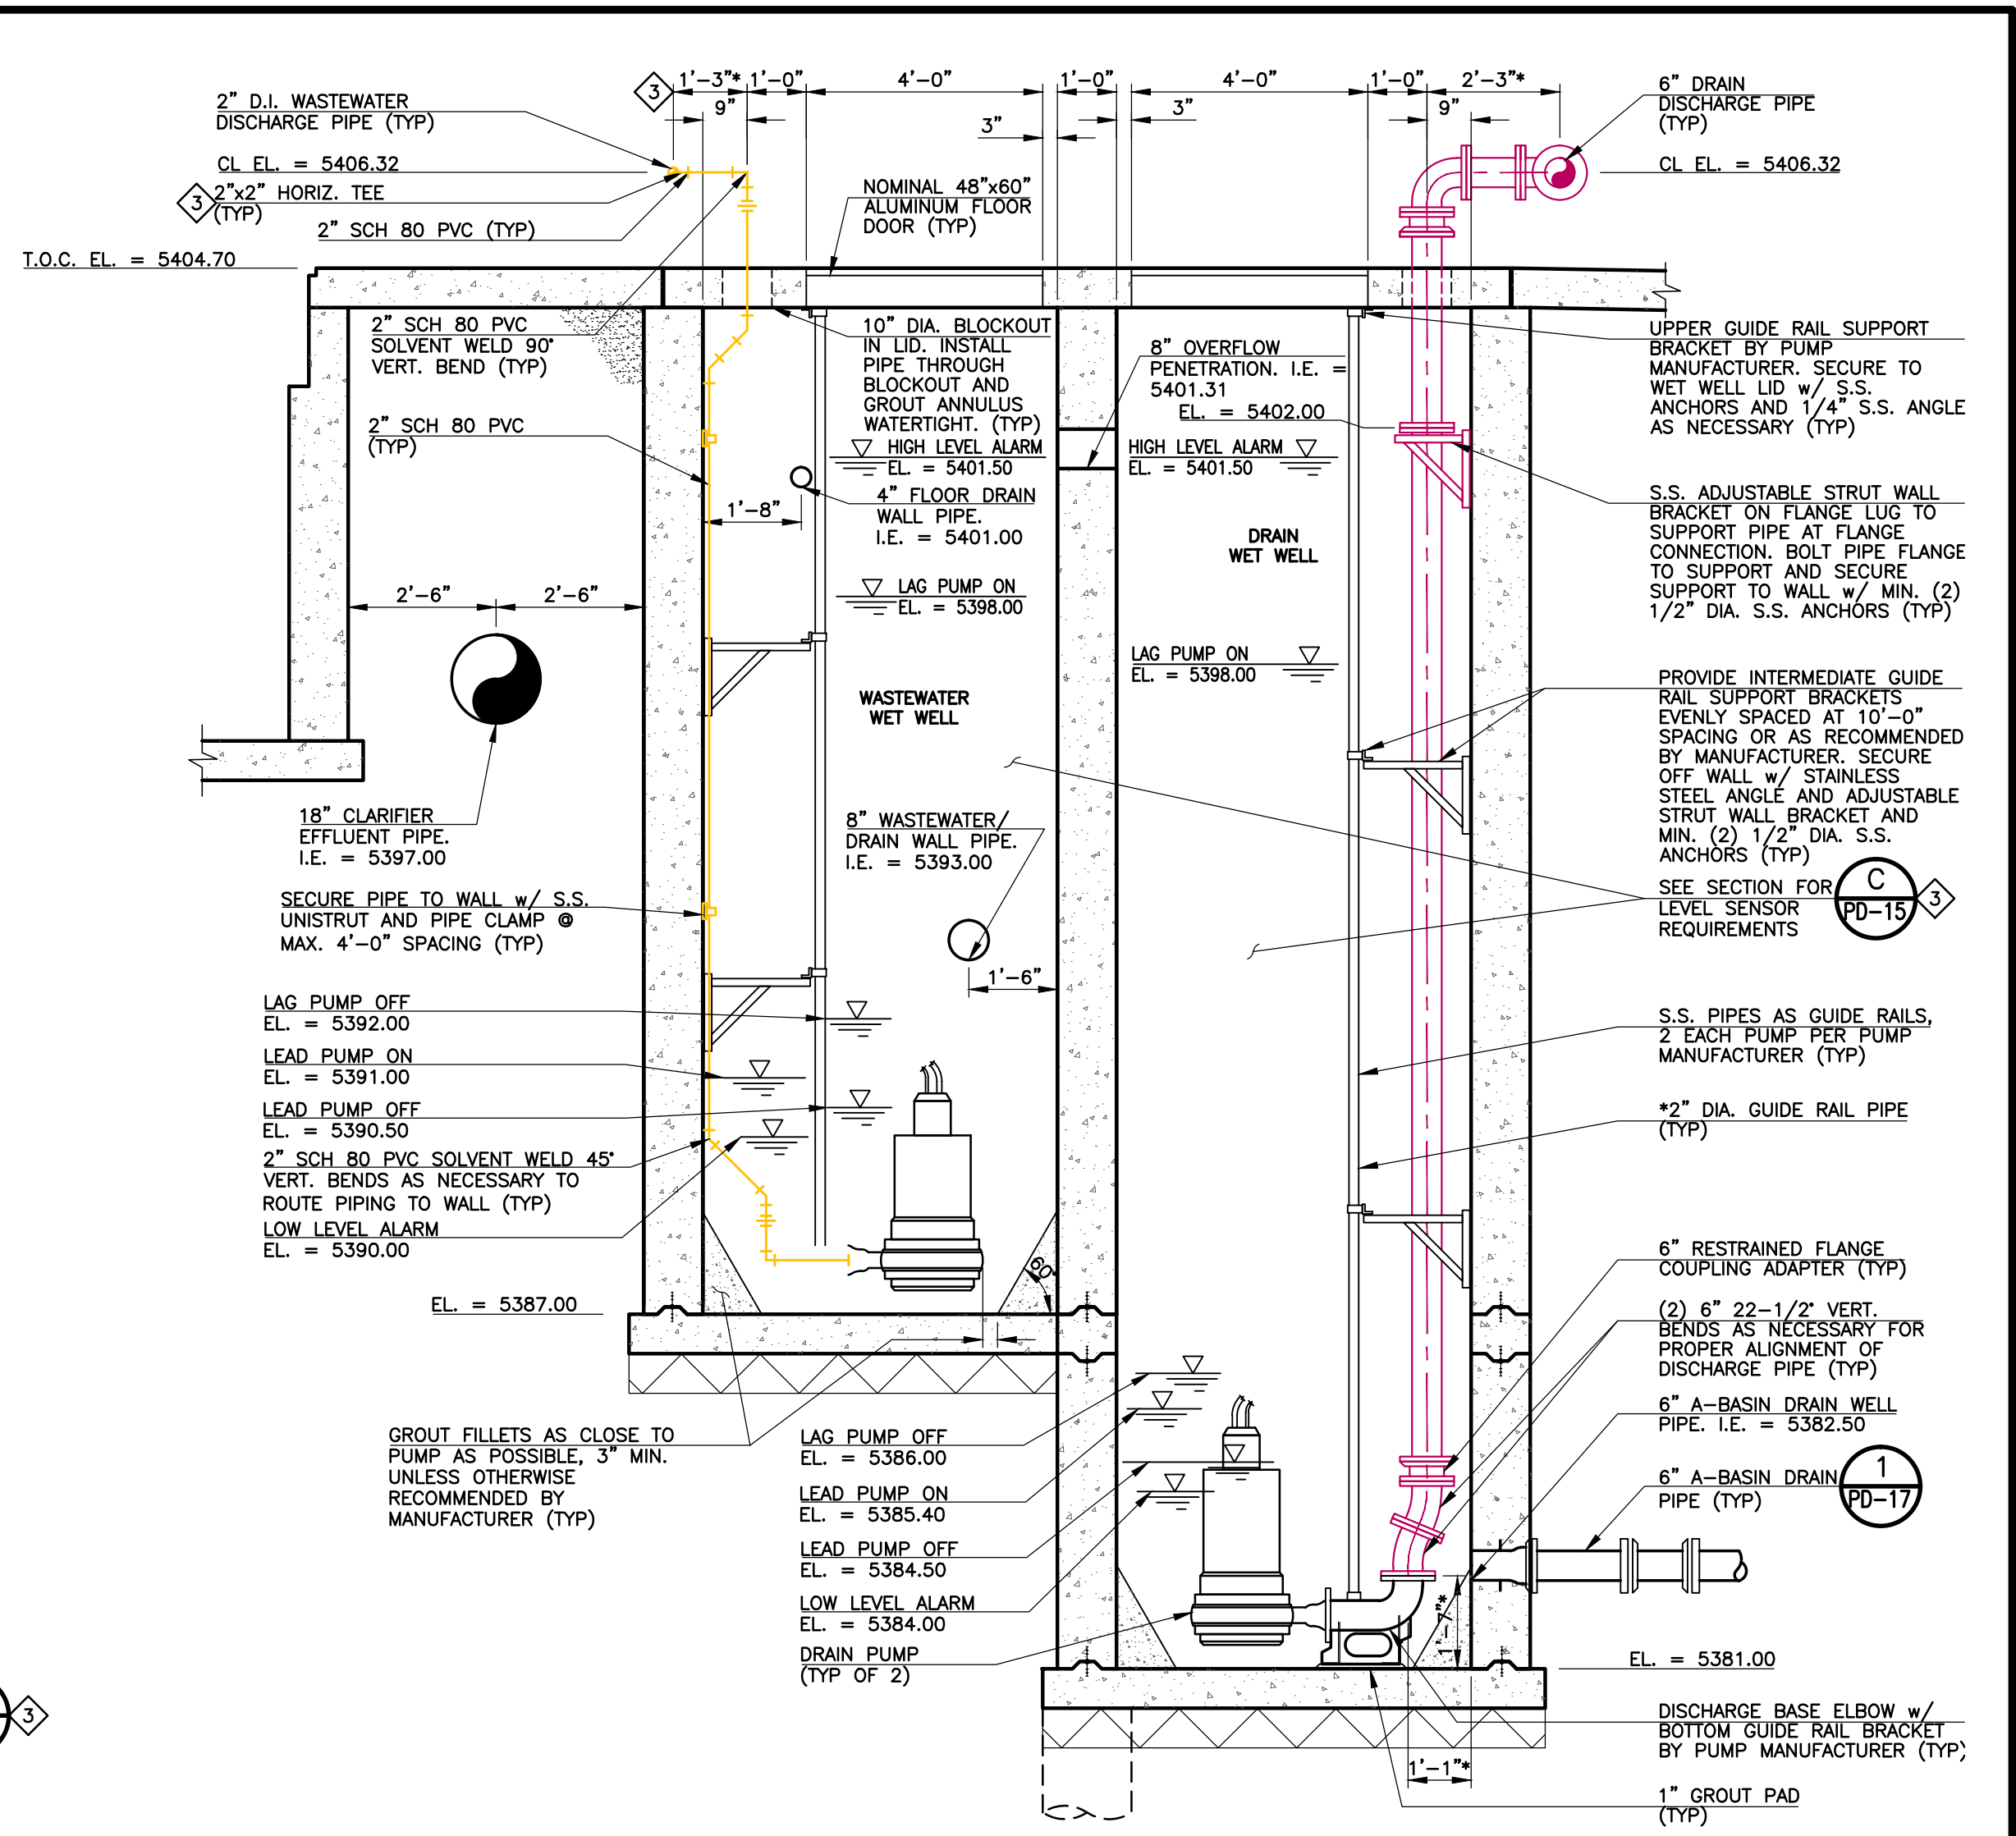

C SECTION
 PD-17 SCALE: 1/2" = 1'-0"

SHEET NOTES:

- * INDICATES VERIFICATION REQUIRED. PRIOR TO CONSTRUCTION, VERIFY ALL DIMENSIONS AND ELEVATIONS RELATIVE TO THE ACTUAL PUMPS AND EQUIPMENT PROVIDED TO ENSURE PROPER ALIGNMENTS AND INSTALLATION CONDITIONS.
- ALL FLOOR TYPE PIPE SUPPORTS SHALL BE PROVIDED AS HOT DIP GALVANIZED OR PAINTED STEEL.
- CONTRACTOR MAY MAKE MINOR ADJUSTMENTS TO THE LOCATIONS OF THE PIPE SUPPORTS SHOWN TO ACCOMMODATE INSTALLATION CONDITIONS.
- SEE PIPING PLAN FOR PIPE COLOR LEGEND.

REVISIONS		
NO.	DATE	DESCRIPTION
1	12/02/2011	ISSUED FOR VALUE ENGINEERING COMMENTS
2	01/09/2012	ISSUED FOR VALUE ENGINEERING
3	01/25/2012	ISSUED FOR PD BUILDING VALUE ENGINEERING REVIEW AND COMMENTS
4	04/18/2012	ISSUED FOR BUILDING PERMIT SUBMITAL TO PRRD (PUMPING AND DISINFECTION BLDG)
5	05/21/2012	ISSUED FOR CONSTRUCTION PER PRRD BLDG PERMIT #8993 (PUMP AND DISINFECTION BLDG)

THIS DRAWING IS THE PROPERTY OF GMS, INC., AND IS NOT TO BE REPRODUCED, MODIFIED OR USED FOR ANY OTHER PROJECT OR EXTENSION OF THIS PROJECT EXCEPT BY AGREEMENT WITH THIS COMPANY.

2011 GMS, INC.

PROCESS PIPING SECTIONS HAROLD D. THOMPSON REGIONAL WATER RECLAMATION FACILITY LOWER FOUNTAIN METROPOLITAN SEWAGE DISPOSAL DISTRICT		GMS, INC. CONSULTING ENGINEERS 611 N. WEBER, SUITE 300 COLORADO SPRINGS, COLORADO 80903	SHEET PD-16 OF —
DRAWN: SKC DESIGNED: MAM CHECKED: RJS DATE: 2011 PROJECT NO.: 20166 GMS FILE NO.: 2599			